



Mét: 23/9 2011
[Signature]

Níels Indriðason^{M1}
 181144-3549

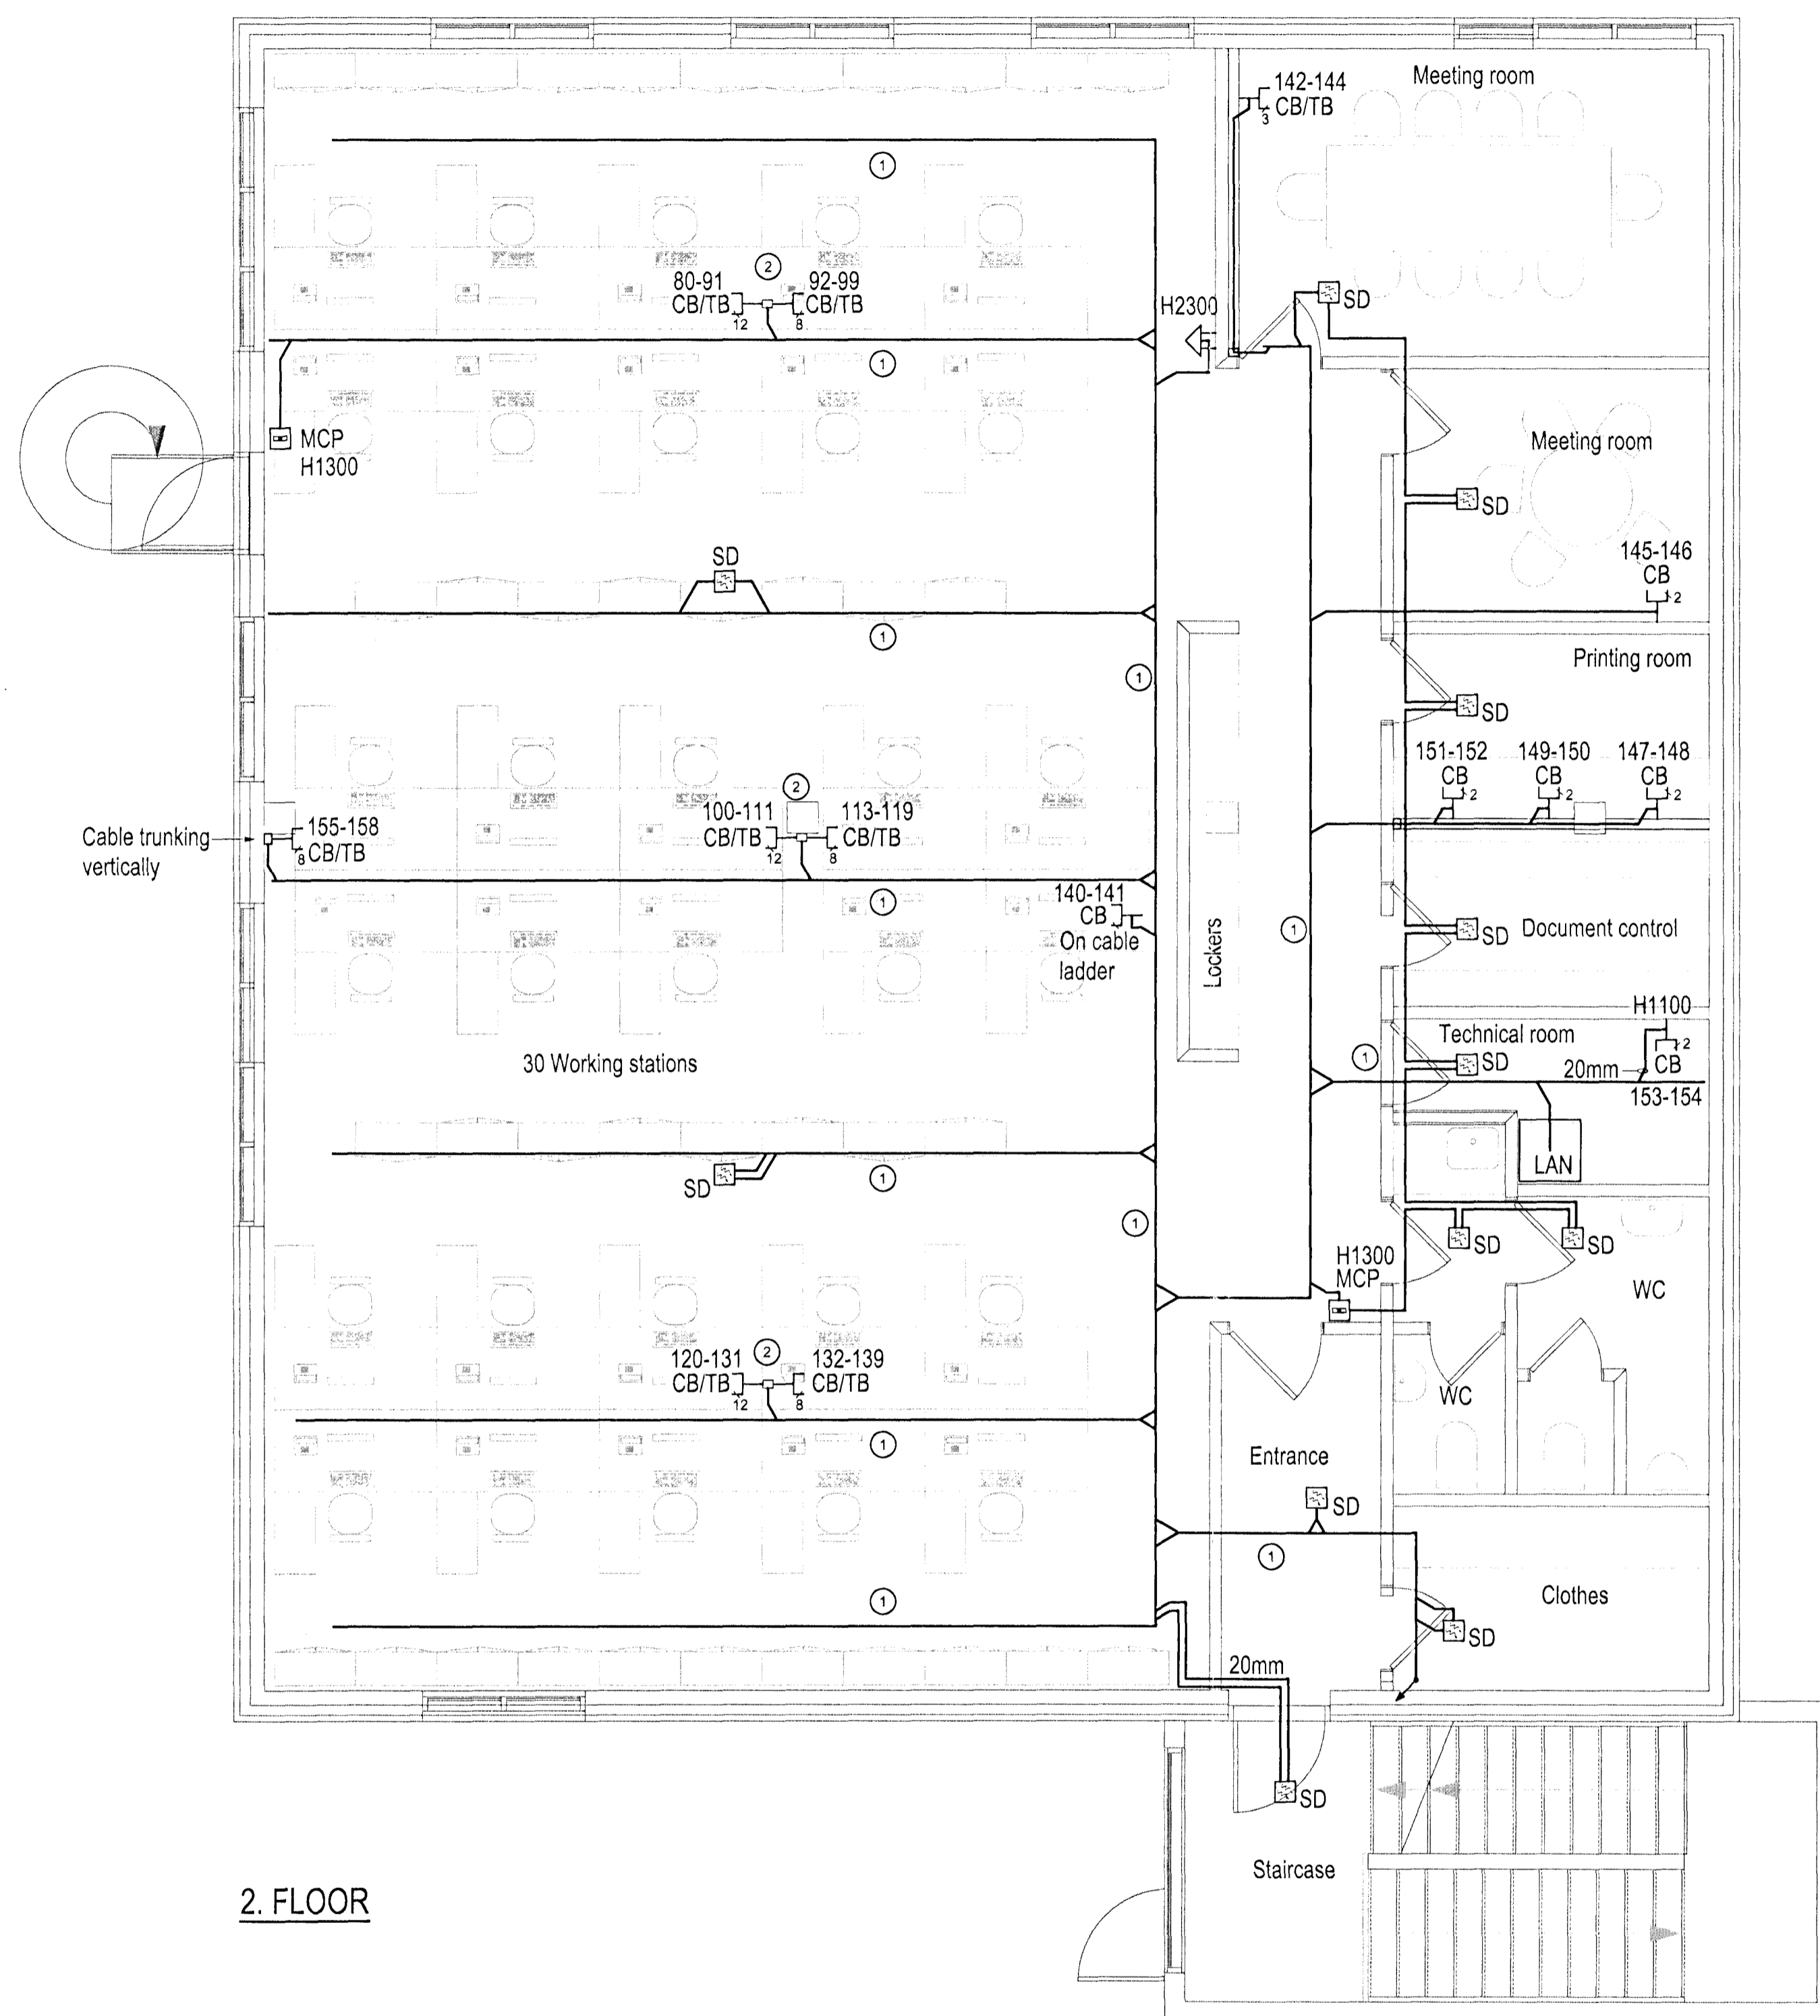

2. FLOOR

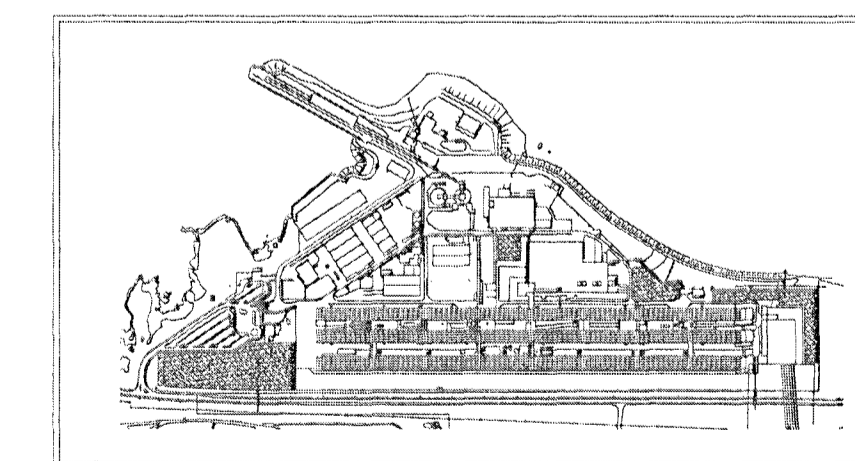


IPU Keyplan - Scale: 1:15000

Skýringar:
 Legend: ① CABLES IN CABLE LADDERS
 ② Outlets, vertical cable trunks

Stig nr / Rev no	Lýsing / Description	Dagsetning / Date	Han/Ún / Des/Drw	Yfir / Old	Notk heim / Suppl Rel	Notk heim / ISAL Rel
3	UPDATE DRAWING	2011.09.08	GJ	ARE		
2	ISSUED FOR CONSTRUCTION	2011.02.25	GJ	ARE	ÓS	MCBW

This drawing is the property of Rio Tinto Alcan Iceland Ltd. and handed out for personal use only. It may neither be copied nor made available to others without permission of Rio Tinto Alcan Iceland Ltd. The receiver is liable for any misuse.

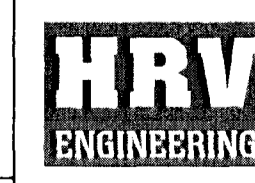

Dagsetning / Date	2010.11.26
Hannað / Designed	GJ
Verktaki / Supplier	HRV
Stað: / Format:	A1
Mkv: / Scale:	1:50
Teikn.nr verktaka / Supplier drw.no.	IPU-872-GB-507-101
Samb. / Approv:	ARE
Hluti af: / Part of:	

IPU 872 - EMCP SITE OFFICE		Flokkur nr.:	Blöð nr.:	Nesta bl. nr.:
ELECTRICAL		Kostn.nr.-Cono. / Búg.nr.-Eq.no		
LAN & FIRE ALARM SYSTEM		AKS		
LAYOUT - 2. FLOOR				
RioTintoAlcan		ISAL	Teikn.nr. ISAL / Drw.no. of ISAL	Breyt./Rev.
ISAL Yfirbúð og útskið, dags / ISAL Checked, date		ISAL Samb. / Approv.	dags / ISAL Approval, date	