



23/9 '11 JT

 
Níel Indriðason
181144 3344

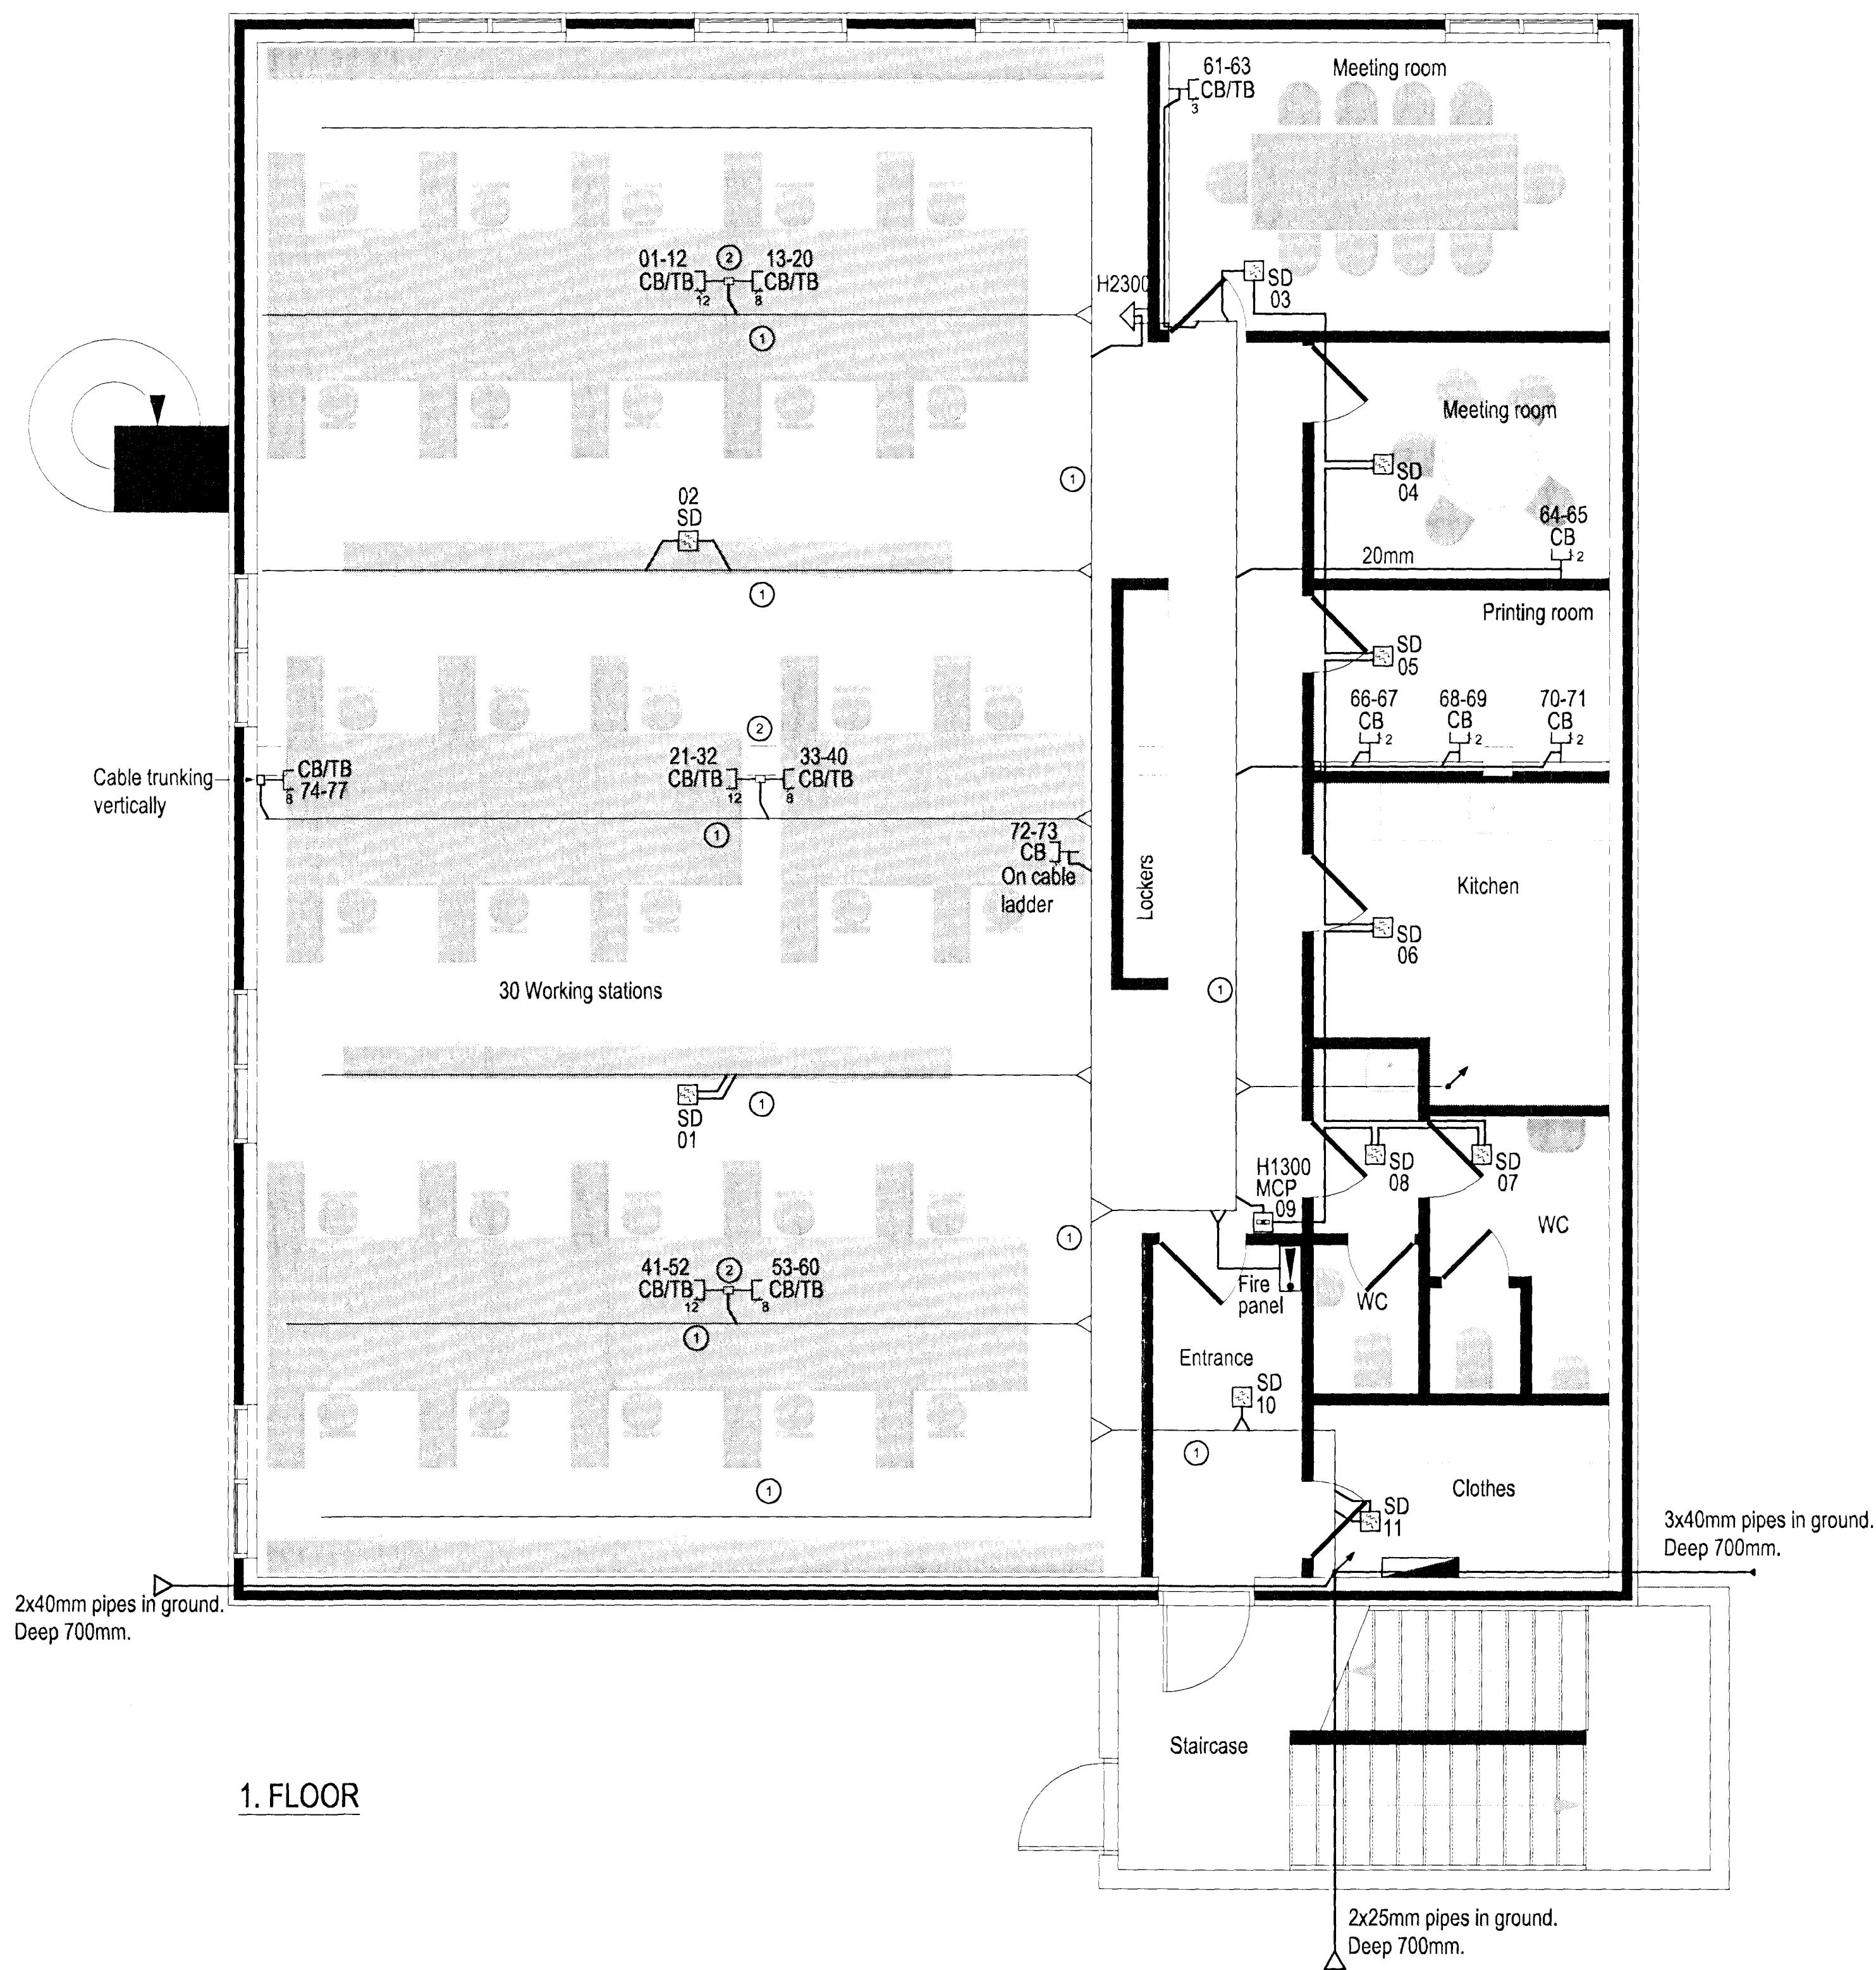

1. FLOOR

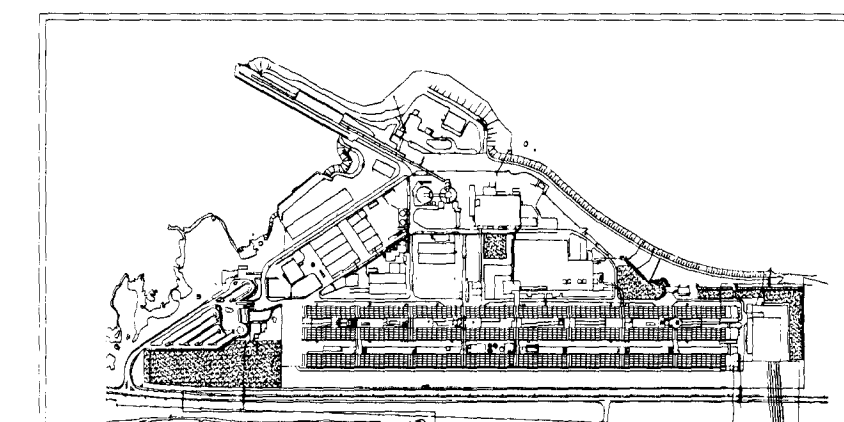

IPU Keyplan - Scale: 1:15000




Skýringar:
Legend:

- ① CABLES IN CABLE LADDERS
- ② Outlets, vertical cable trunks

Stj nr / Rev no	Lýsing / Description	Dagsetning / Date	Har/Út / Des/Drw	Yftr / Chk /	Notk heim / Supp / ISAL Ref
4	UPDATE DRAWING	2011.09.08	GJ	ARE	
3	ADDING PIPES IN GROUND	2011.03.21	GJ	ARE	ÓS MCBW
2	ISSUED FOR CONSTRUCTION	2011.02.25	GJ	ARE	ER MCBW

This drawing is the property of Rio Tinto Alcan Iceland Ltd. and handed out for personal use only. It may neither be copied nor made available to others without permission of Rio Tinto Alcan Iceland Ltd. The receiver is liable for any misuse.

Stærð / Format: A1 Mkv: / Scale: 1:50
 Dimensjónir án töluranna samkvæmt ISO 2768-1 meðlim.

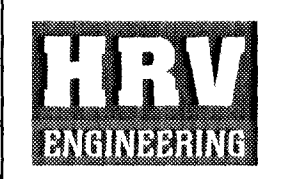

Dagsetning / Date	2010.11.26
Hannað / Designed	GJ
Teikn / Drawn	pLI
Verktaki / Supplier	HRV
Teikn nr. verskila / Supplier draw no	IPU-872-CB-507-001
Sampykkt / Approved	Yftr / Chk / ARE
Hluti af: / Part of:	

IPU 872 - EPCM SITE OFFICE		Flekkur nr.:	Bláð nr.:	Næsta bl. nr.:
ELECTRICAL		Kostnaður - Cost. / Bgr nr. - Eq no		
LAN & FIRE ALARM SYSTEM		Aks		
LAYOUT - 1.FLOOR		Tekn. nr. ISAL / Drw. no. of ISAL		
Rio Tinto Alcan		Breyt / Rev. C		
Alcan Iceland Ltd Straumsvík IS-222 Hafnarfordur Ísland		ISAL Yfirfærð og skráð, dags / ISAL Checked, date		
ISAL Yfirfærð og skráð, dags / ISAL Checked, date		ISAL Sampykkt, dags / ISAL Approved, date		