

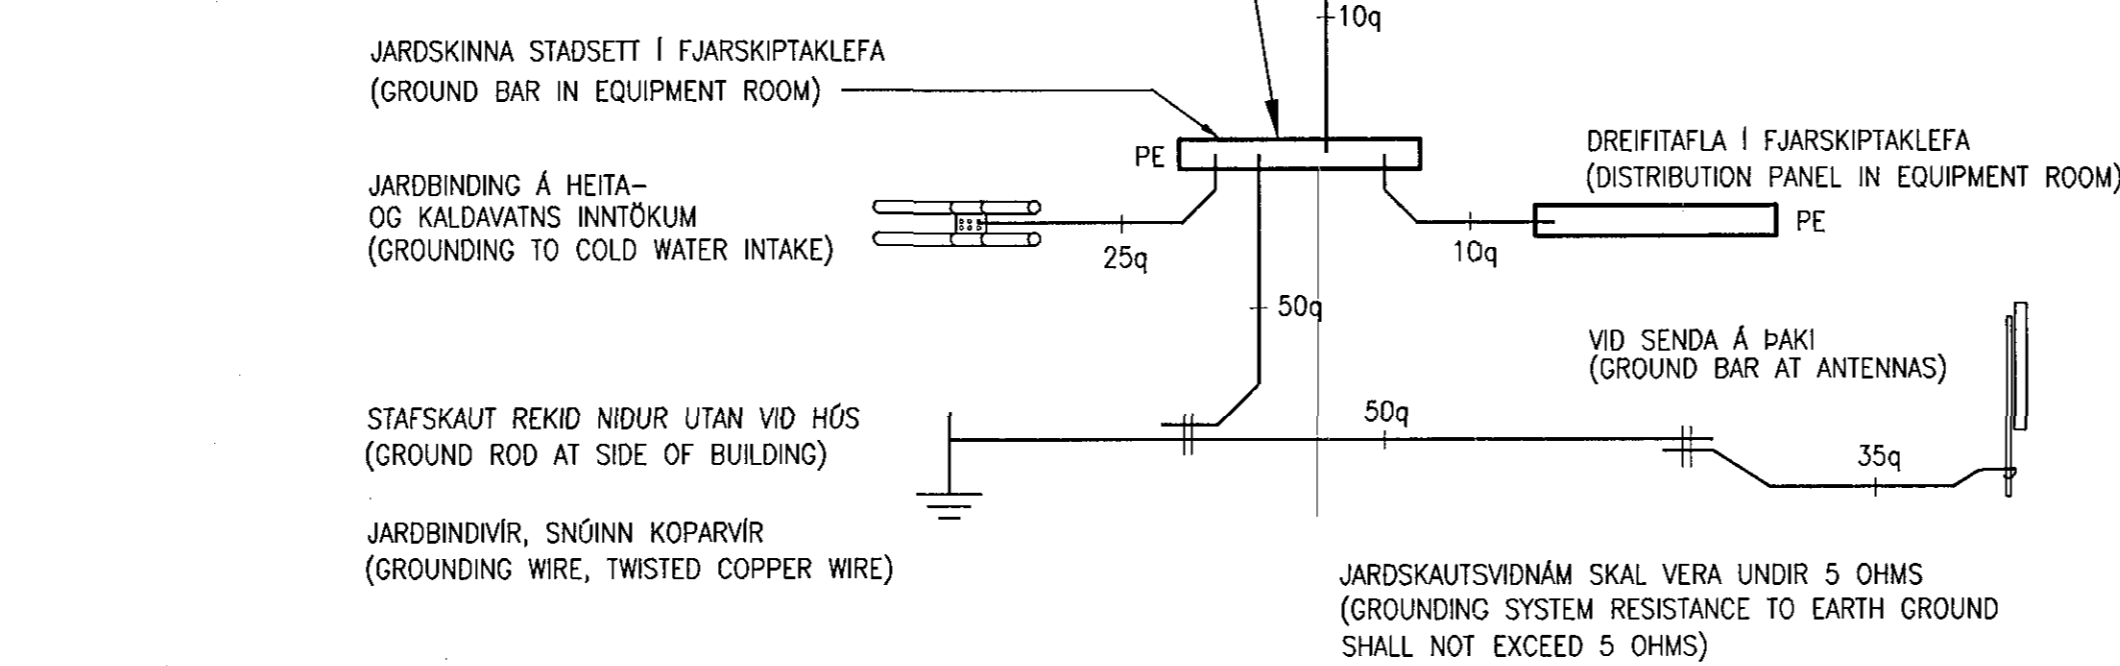
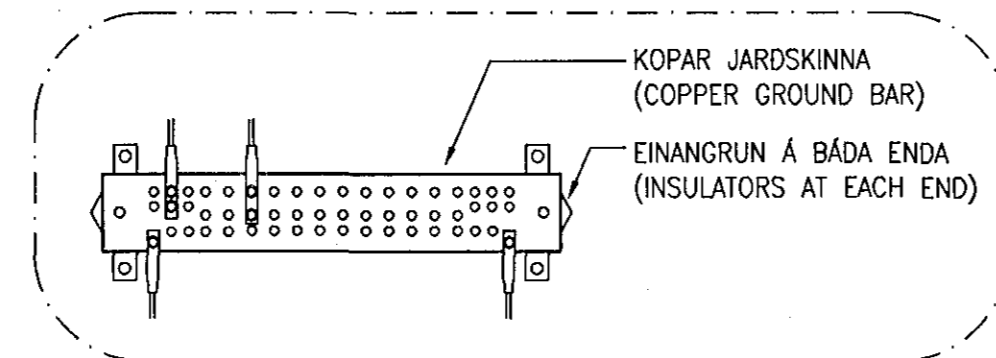
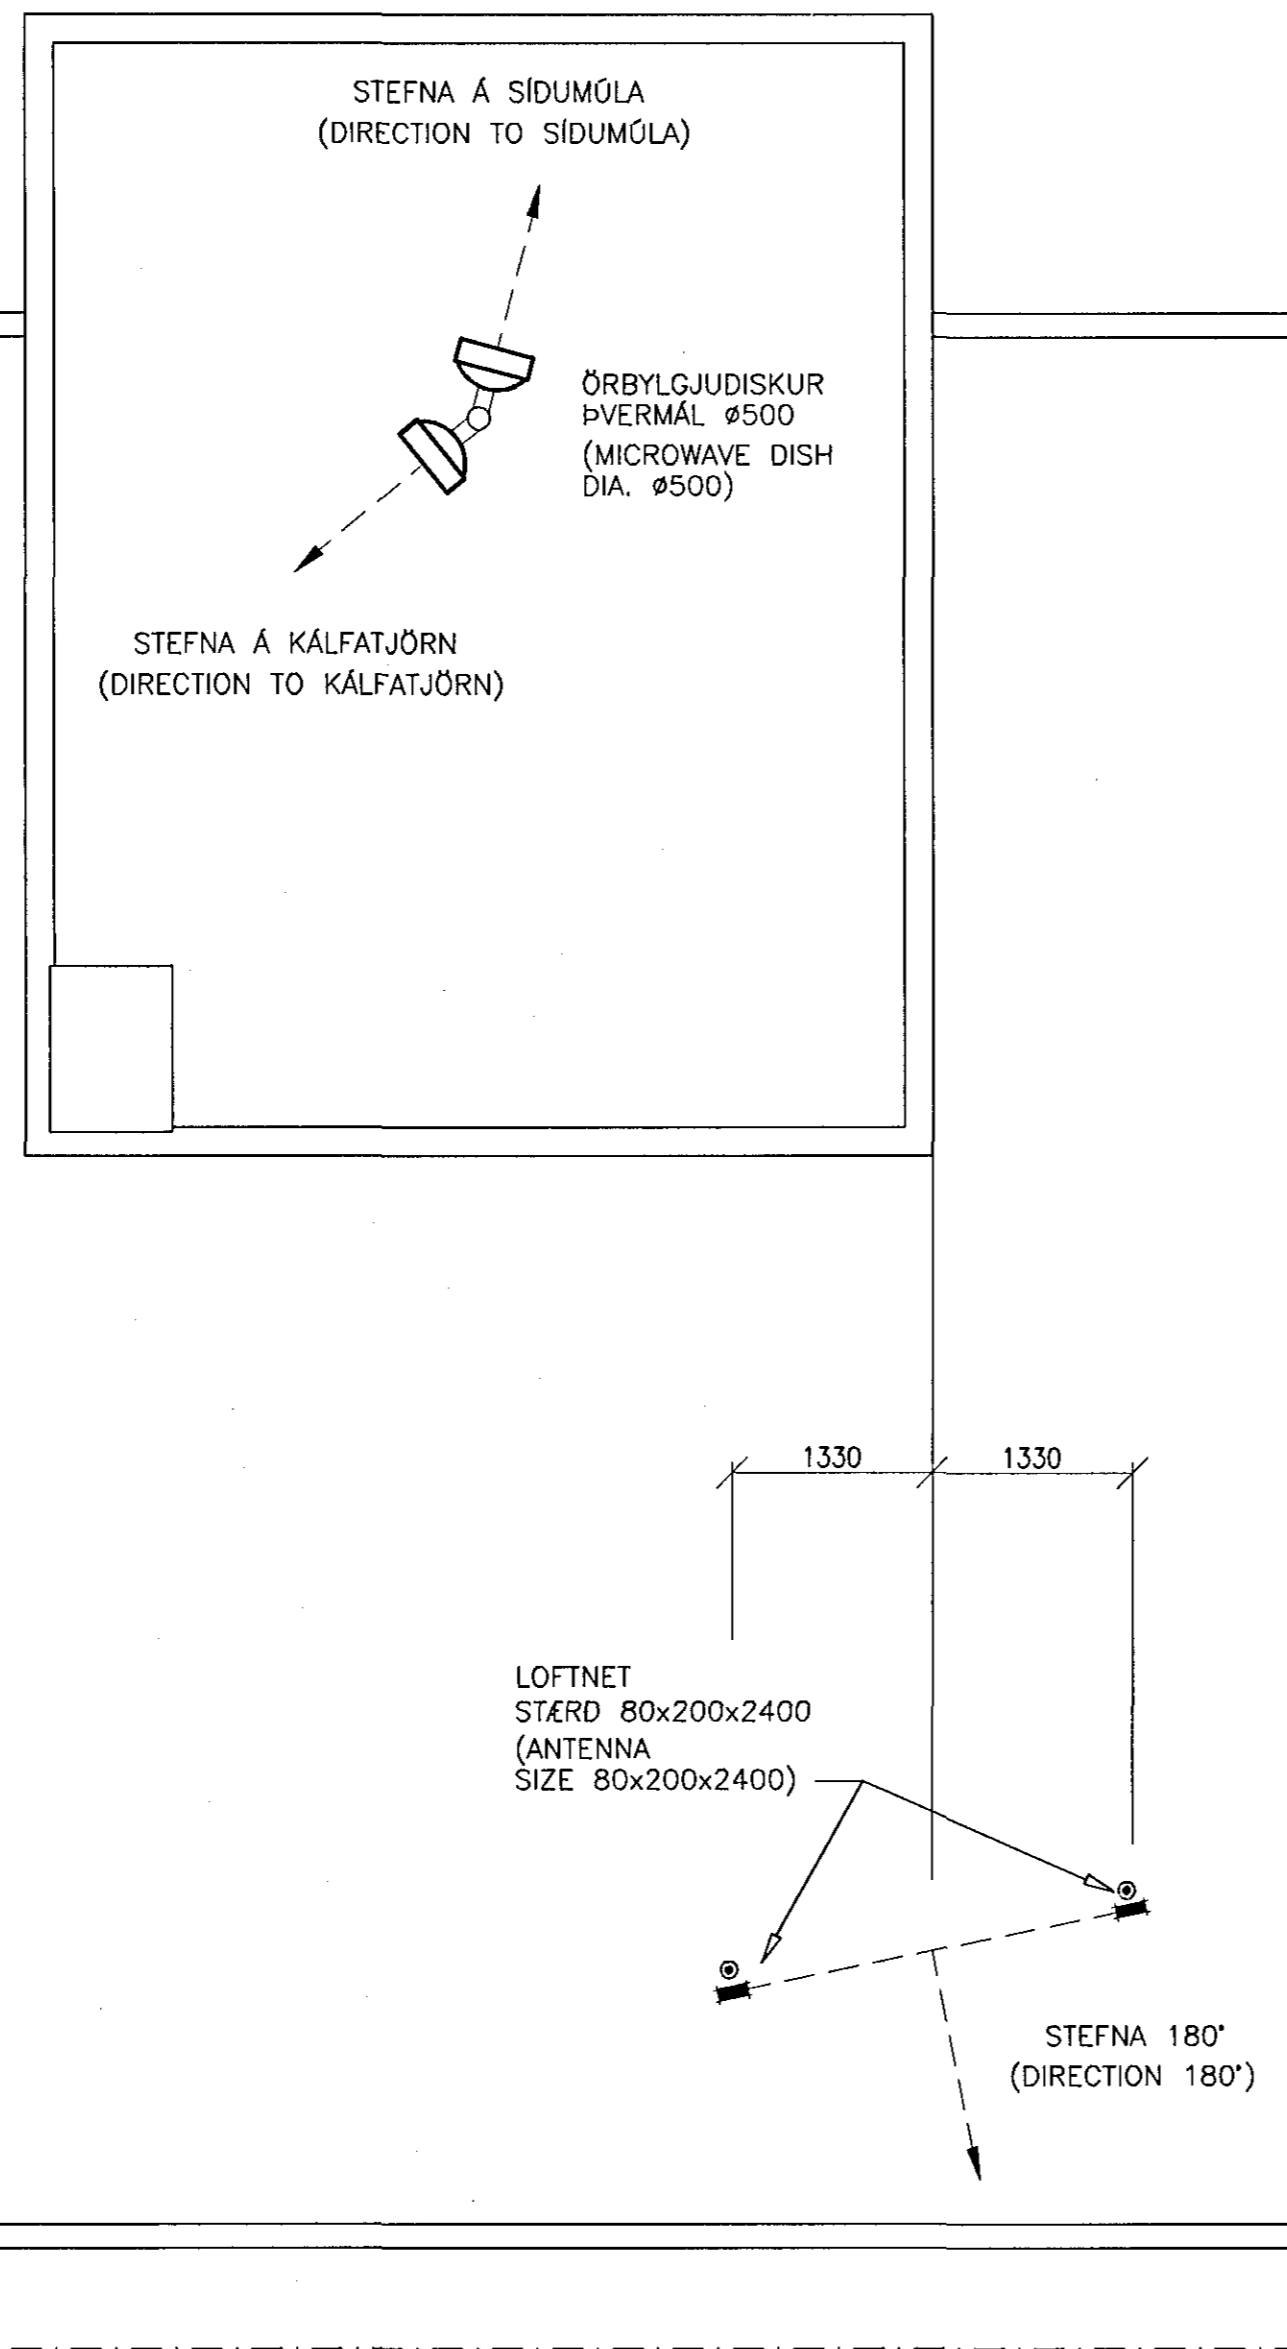


ÞAKMYND LOFTNET MKV 1:50
(ROOF PLAN ANTENNAS SCALE 1:50)

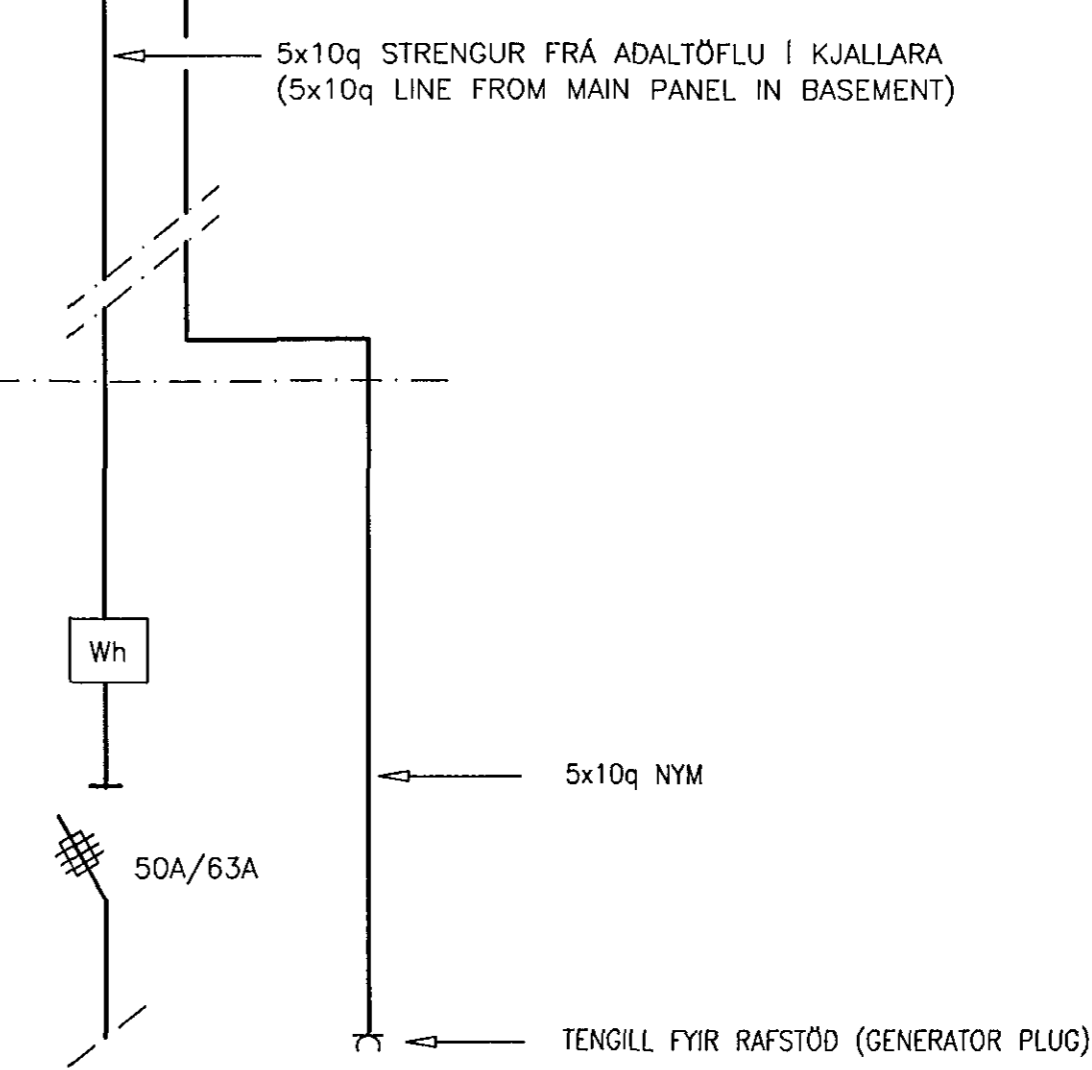

JARDTENING (GROUNDING)

JARDSKAUTSVIÐNÁM SKAL VERA UNDIR 5 OHMS
(GROUNDING SYSTEM RESISTANCE TO EARTH GROUND SHALL NOT EXCEED 5 OHMS)

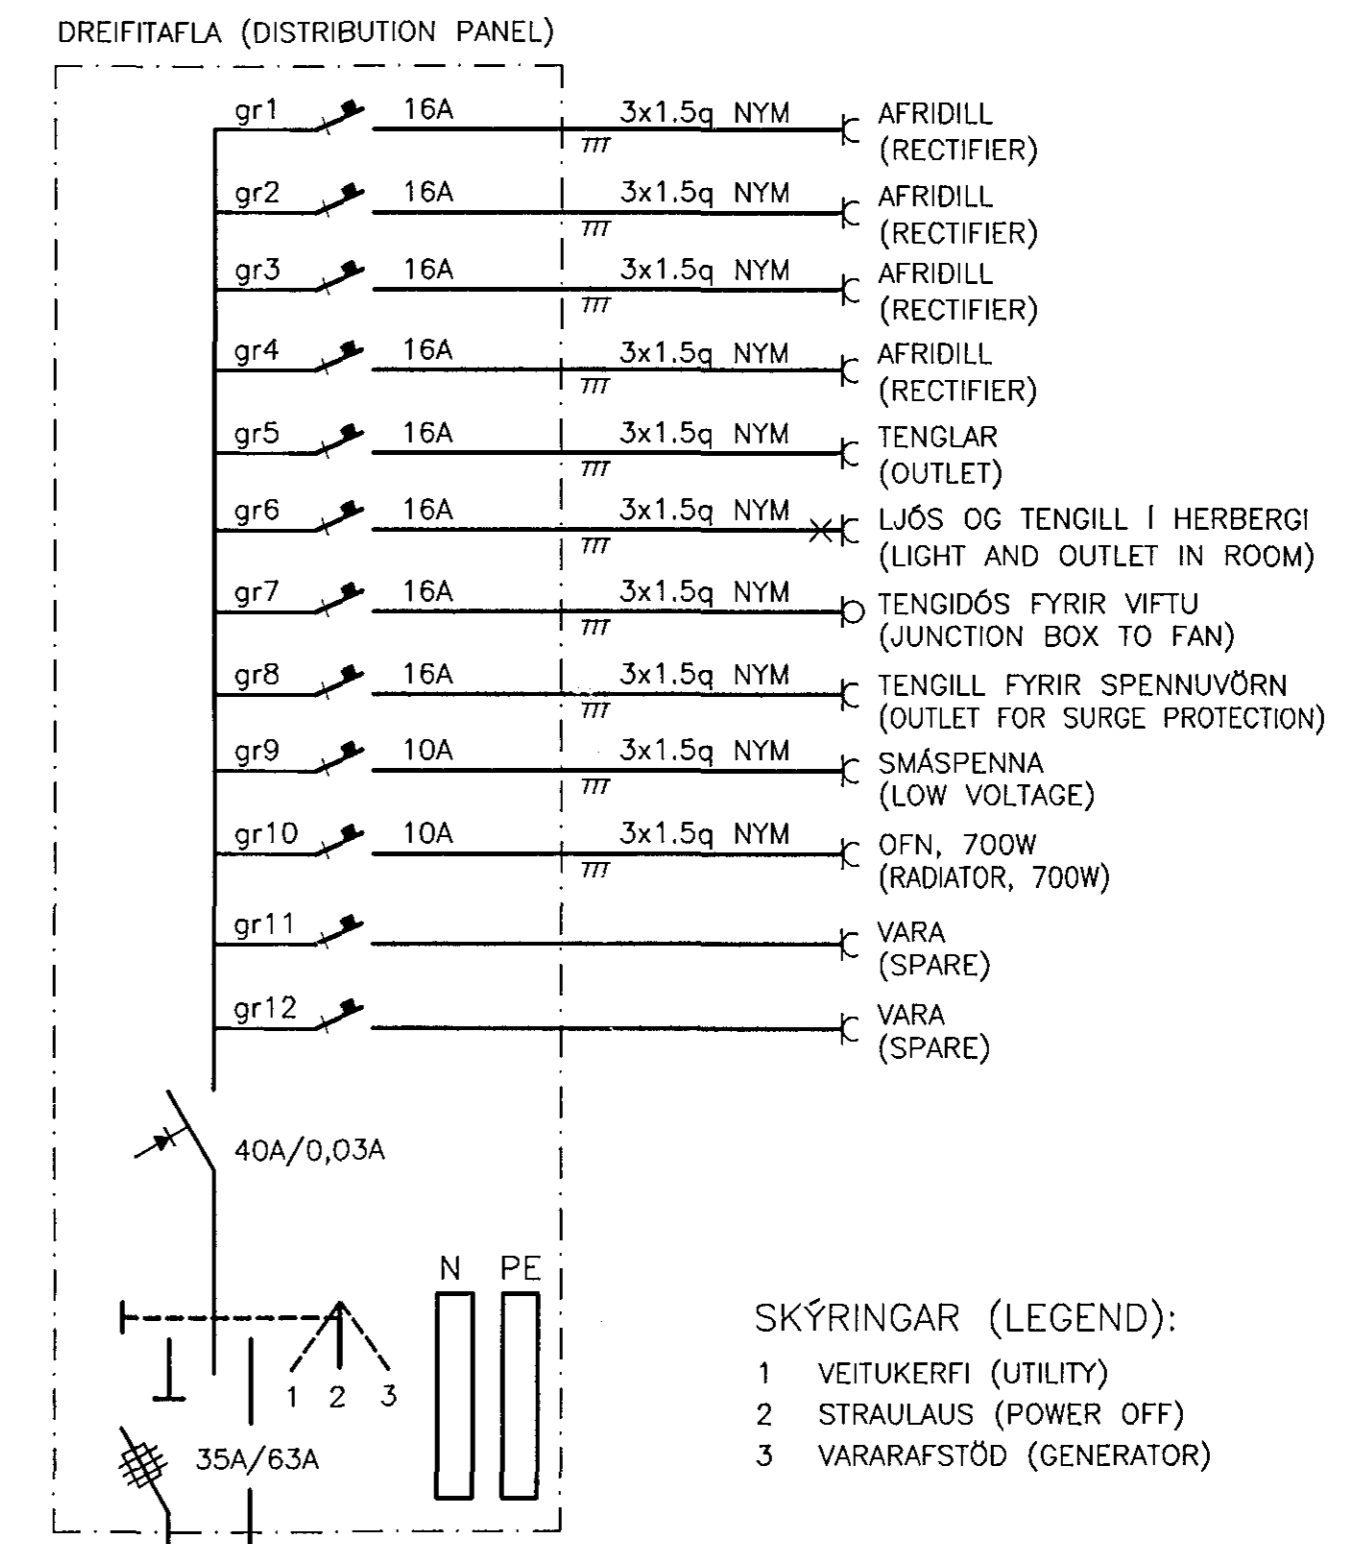

EINLÍNEMYND FYRIR RAFMAGNSTÖFLU
(ONE LINE DIAGRAM FOR EL-PANEL)

MÍÐVANGUR 41

121904

DAGS 28.11.97

BREYTINGAR		
NR.	DAGS.	BREYTING

Íslenska farsímafélagið ehf
 Borgartún 24
 105 Reykjavík
 Sími 552 7811
 Fax 562 7186
 Kf. 660397-2729

KLÖPP
 KLÖPP ARKITEKTAR - VERKFRÉDINGAR EHF
 HVERFISGATA 46, 101 REYKJAVÍK
 Sími 552 7777 FAX 562 3074

ÞESSI TEIKNING ER MEÐ HÖFUNÐARRÉTTI EIGANDA OG ER EINGINGIS TIL NOTKUNAR FYRIR EIGANDA OG HANS STARFSSEMI. ENDURRIT EDA NOTKUN Á ÞESSARI TEIKNINGU OG/EDA UPPLÝSINGUM Á TEIKNINGUNNI ERU BANNADAR NEMA AD FENGNU SKRIFLEGU LEYFI EIGANDA.

VERKHEITI

MÍÐVANGUR 41
FJARSKIPTABÚNAÐUR

LANDNÓMUR

121904

STADSETNING

MÍÐVANGUR 41
220, HAFNARFJÖRDUR

TEIKNINGARHEITI

RAFLAGNIR,
EINLÍNEMYNDIR
OG ÞAKMYND

TEIKNINGARNÓMUR

R 002

MÆLIKVARDI MKV 1:50

