




ÞAKMYND, COAX-KAPLAR MKV 1:100
(ROOF PLAN, COAX CABLES SCALE 1:100)

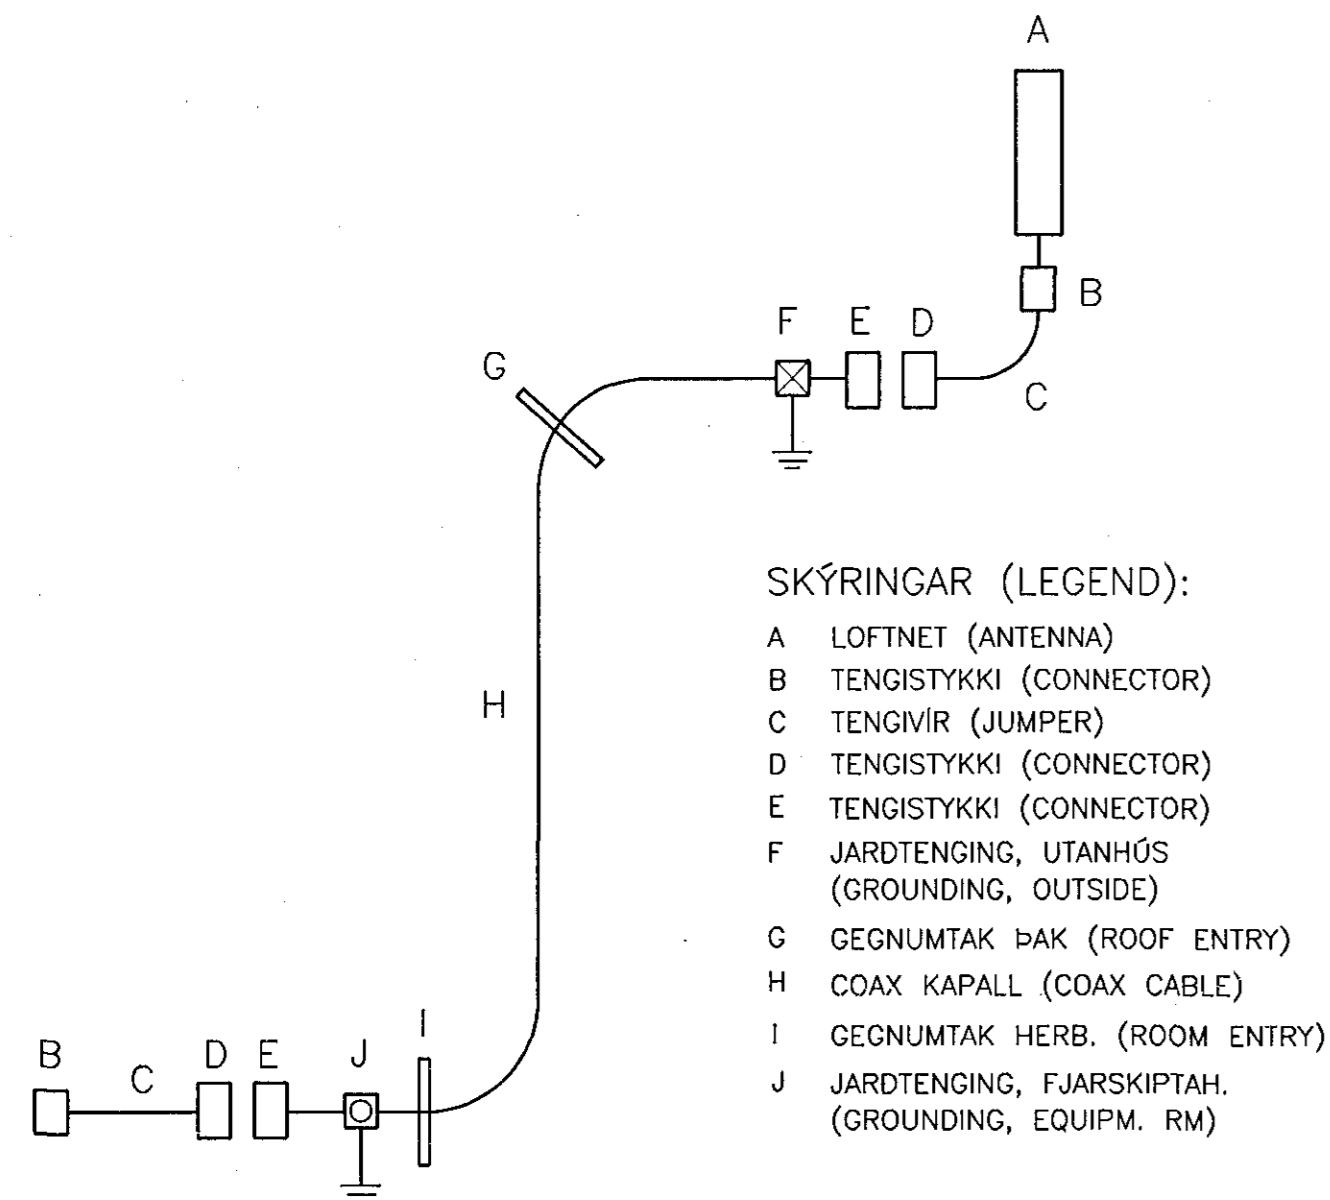

COAX KAPALL, EINLÍNEMYND
(COAX CABLE, ONE LINE DIAGRAM)

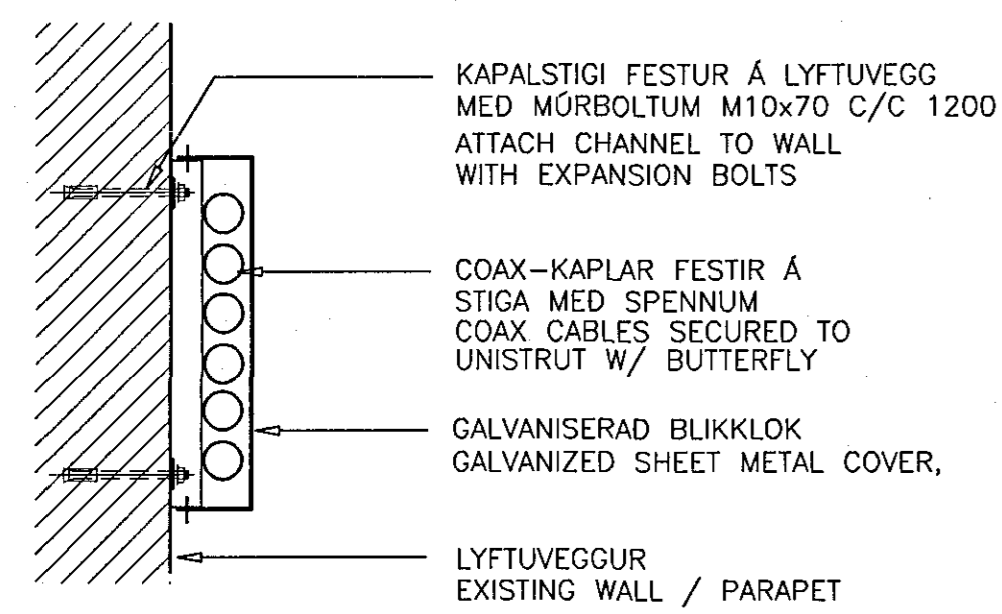


KAPALSTIGI Í LYFTUSTOKK MKV 1:10
(CABLE LADDER IN LIFT SHAFT SCALE 1:10)

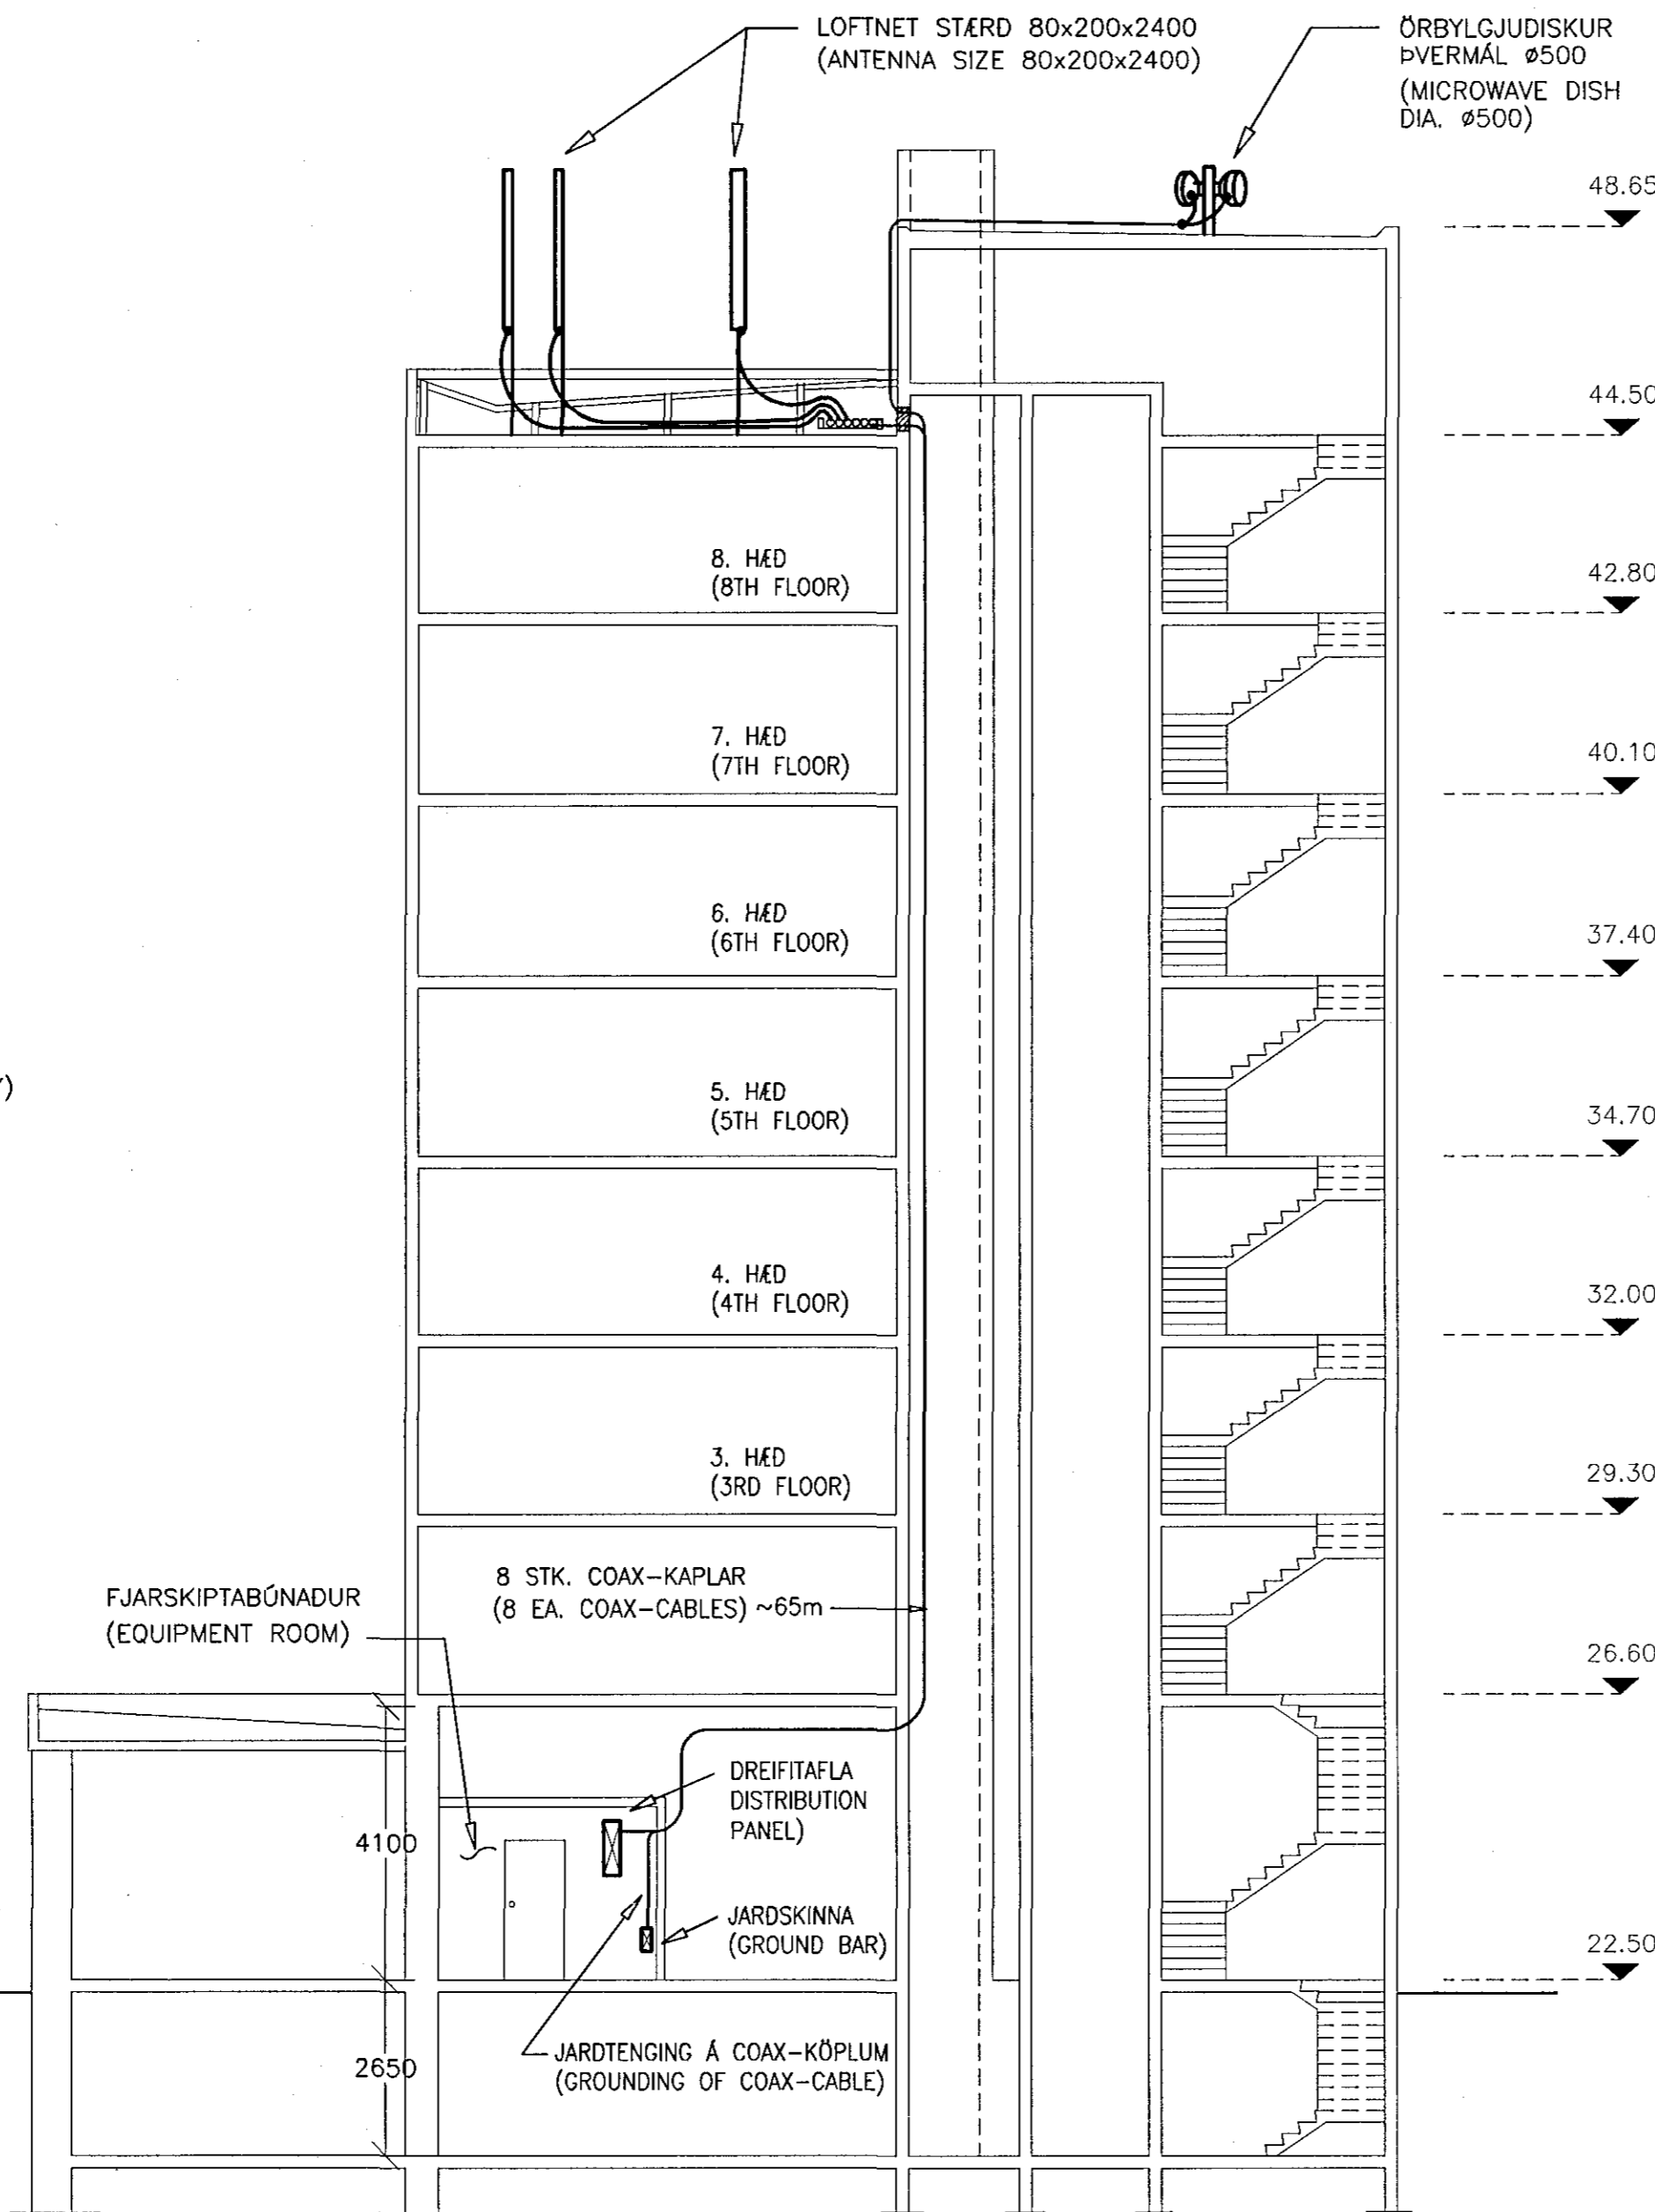


SNIÐ MKV 1:100
(SECTION SCALE 1:100)

R002
1

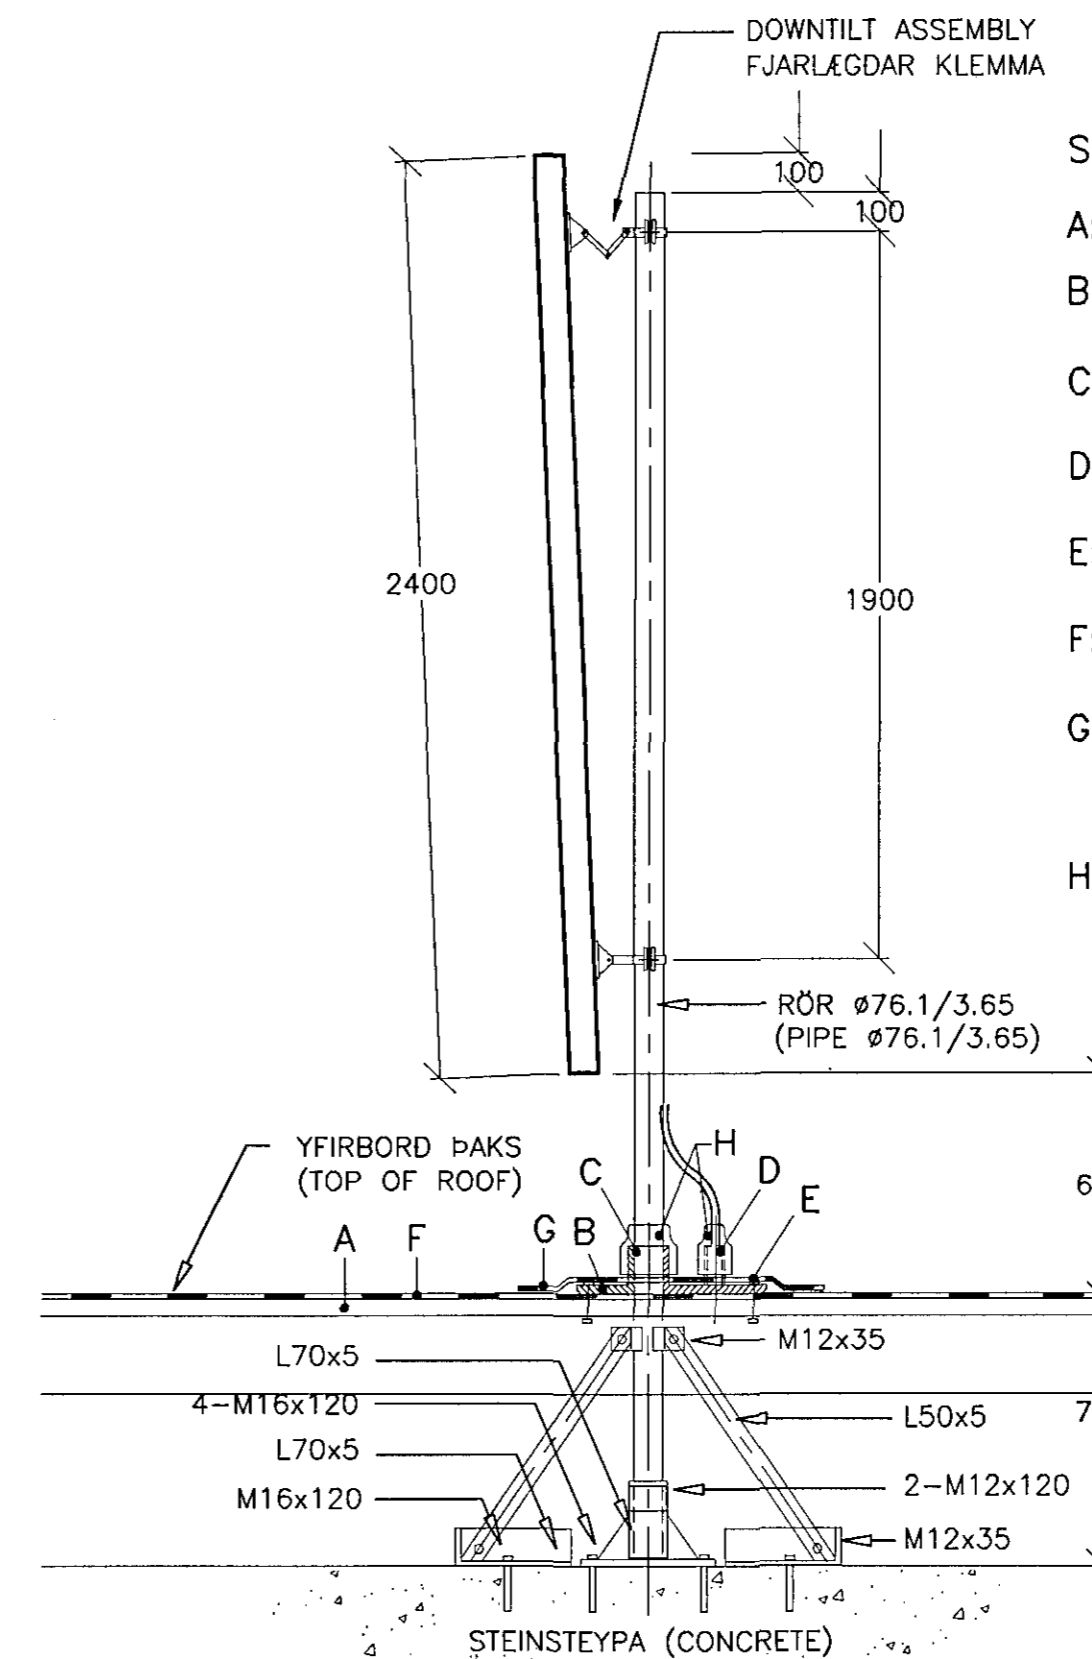

LOFTNETSFESTINGAR Á ÞAKI MKV 1:20
(ANTENNA SUPPORT ON ROOF SCALE 1:20)

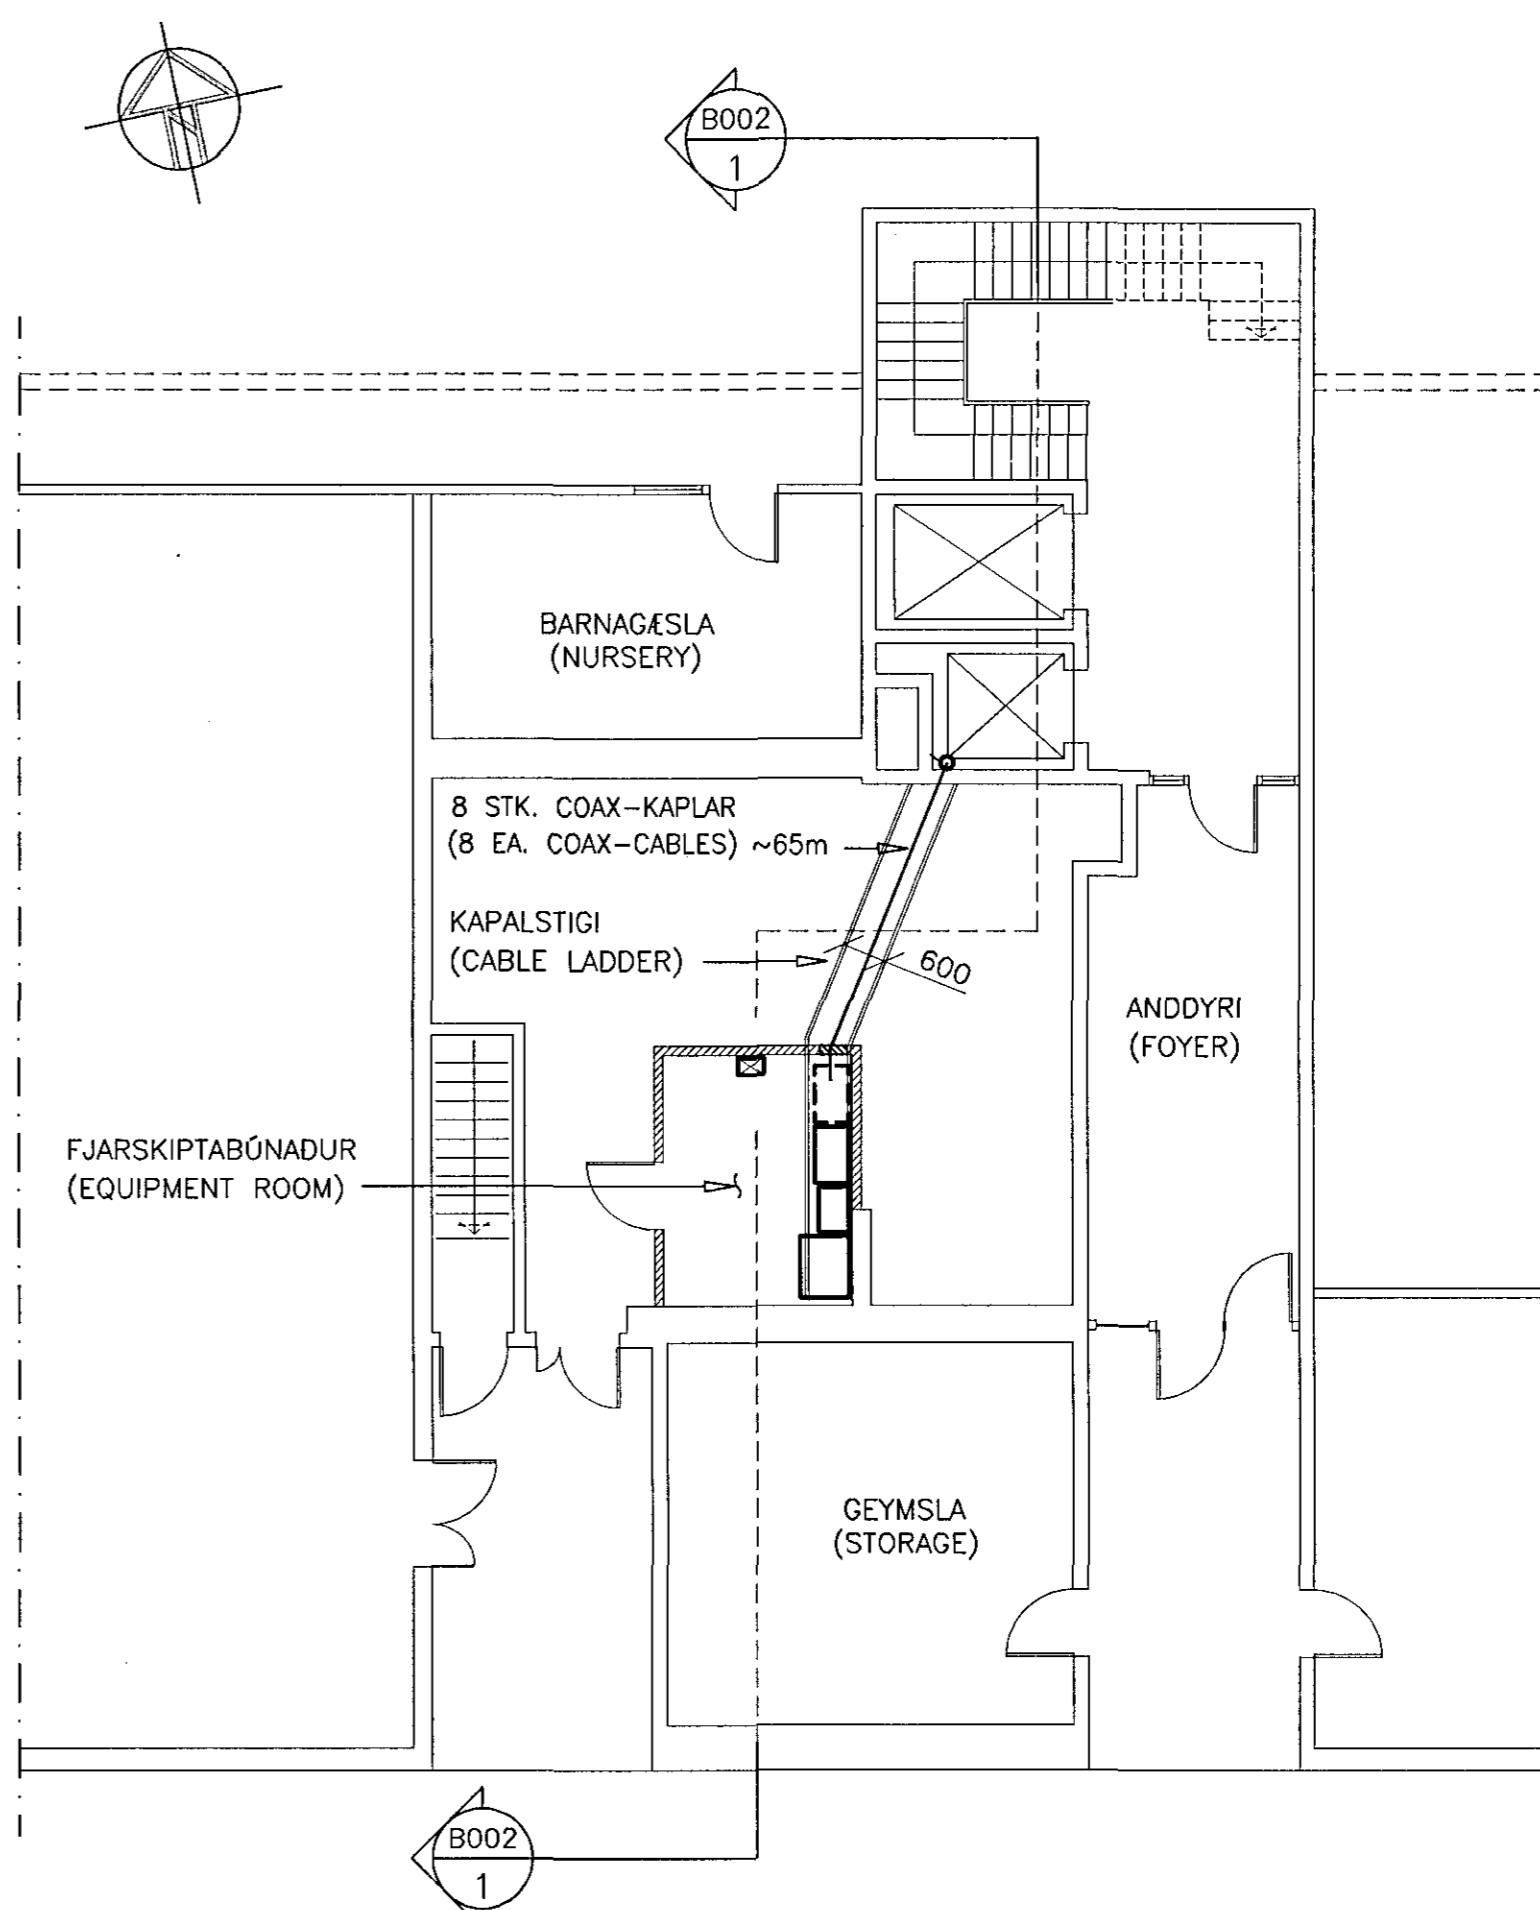

GRUNNMYND, 1.HÆÐ MKV 1:100
(1ST FLOOR PLAN SCALE 1:100)

SKÝRINGAR (LEGEND):

- A: VIDARÞAK (WOODEN ROOF)
- B: STÁLPLATA 5x500x500 (STEEL PLATE 5x500x500)
- C: STÁL RÖR, UTANMÁL 89mm (STEEL PIPE OUTER DIM. 89mm)
- D: STÁL RÖR, UTANMÁL 53mm (STEEL PIPE OUTER DIM. 53mm)
- E: GAT 11mm, BOLTAR 10x50mm (HOLE 11mm, BOLTS 10x50mm)
- F: TJÖRUDÚKUR Á ÞAKI (ASPHALT LAYER ON ROOF)
- G: NÝR TJÖRUDÚKUR ~0,8x0,8mm (NEW ASPHALT LAYER ~0.8x0.8mm OVER STEEL PLATE)
- H: RÖR ÞÉTT MED GÓMHÖLK OG SILÍSIUM (PIPE SEALED WITH RUBBER GASKET AND SILICON)


MÍÐVANGUR 41

121904

DAGS 28.11.97

BREYTINGAR

NR.	DAGS.	BREYTING
1	30.01.97	FESTING OG ÞÉTTING LOFTNETA
2		
3		
4		
5		
6		

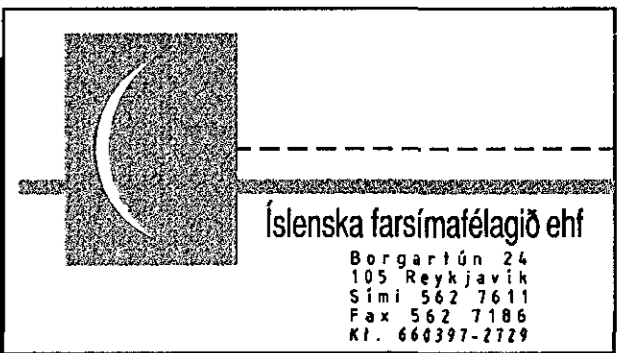

ÞESSI TEIKNING ER MED HÖFUNDARRÉTTI EIGANDA OG ER EINUNGIS TIL NOTKUNAR FYRIR EIGANDA OG HANS STARFSSEMI. ENDURRIT EDA NOTKUN Á ÞESSARI TEIKNINGU OG/EDA UPPLÝSINGUM Á TEIKNINGUNNI ERU BANNADAR NEMA AD FENGNU SKRIFLEGU LEYFI EIGANDA.

VERKHEITI

MÍÐVANGUR 41
FJARSKIPTABÚNAÐUR

LANDNÓMUR

121904

STADSETNING

MÍÐVANGUR 41
220, HAFNARFJÖRÐUR

TEIKNINGARHEITI

COAX-KAPLAR,
GRUNNMYNDIR, ÞAK,
EINLÍNEMYND OG SNIÐ

TEIKNINGARNÓMUR

R 003

MELIKVARDI MKV 1:100 / 1:10 / 1:20