


HANNAFJÖRÐUR
 BYGGINGAFLURDINN
 28.3.96
 AFGRETT
 (Signature)

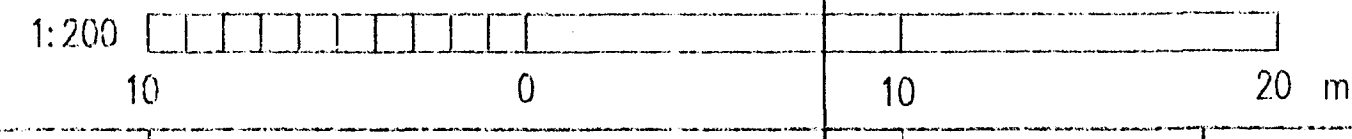

VST CONSULTING ENGINEERS Ltd. Armula 4 108 Reykjavik Iceland Tel: +354 569 5000 Fax: +354 569 5010		95.120 - 12.102	
ICELANDIC ALUMINIUM COMPANY LTD.		POTROOM NO. 3 CONCRETE WORK FOUNDATION PLAN, PART 1/4 FORMWORK	
DRAWN: 95.10.28 FGS APPROVED: 95.10.28 KCS PROCESS: 95.10.28 NI PROJECT: 95.10.28 NI SCALE: 1:200 FORMAT: A1	ALUSUISSE ENGINEERING LTD. ZÜRICH SWITZERLAND		79000-32302
ICELANDIC ALUMINIUM CO. LTD.		186.602	

REV. NO.	DATE	REVISION	BY	APP.	REV. NO.	DATE	REVISION	BY	APP.	NOTES	REFERENCE DRAWING	DRAWING NUMBER
3	1996.03.18	RECTIFIER AREA REVISION	FGS	N.I.								
2	1996.01.23	SUBSTATIONS AND EI-PIPES	FGS	N.I.								
1	1996.01.02	APPROVED FOR CONSTRUCTION	FGS	N.I.								