



FOUNDATION PLAN EL. -1.40

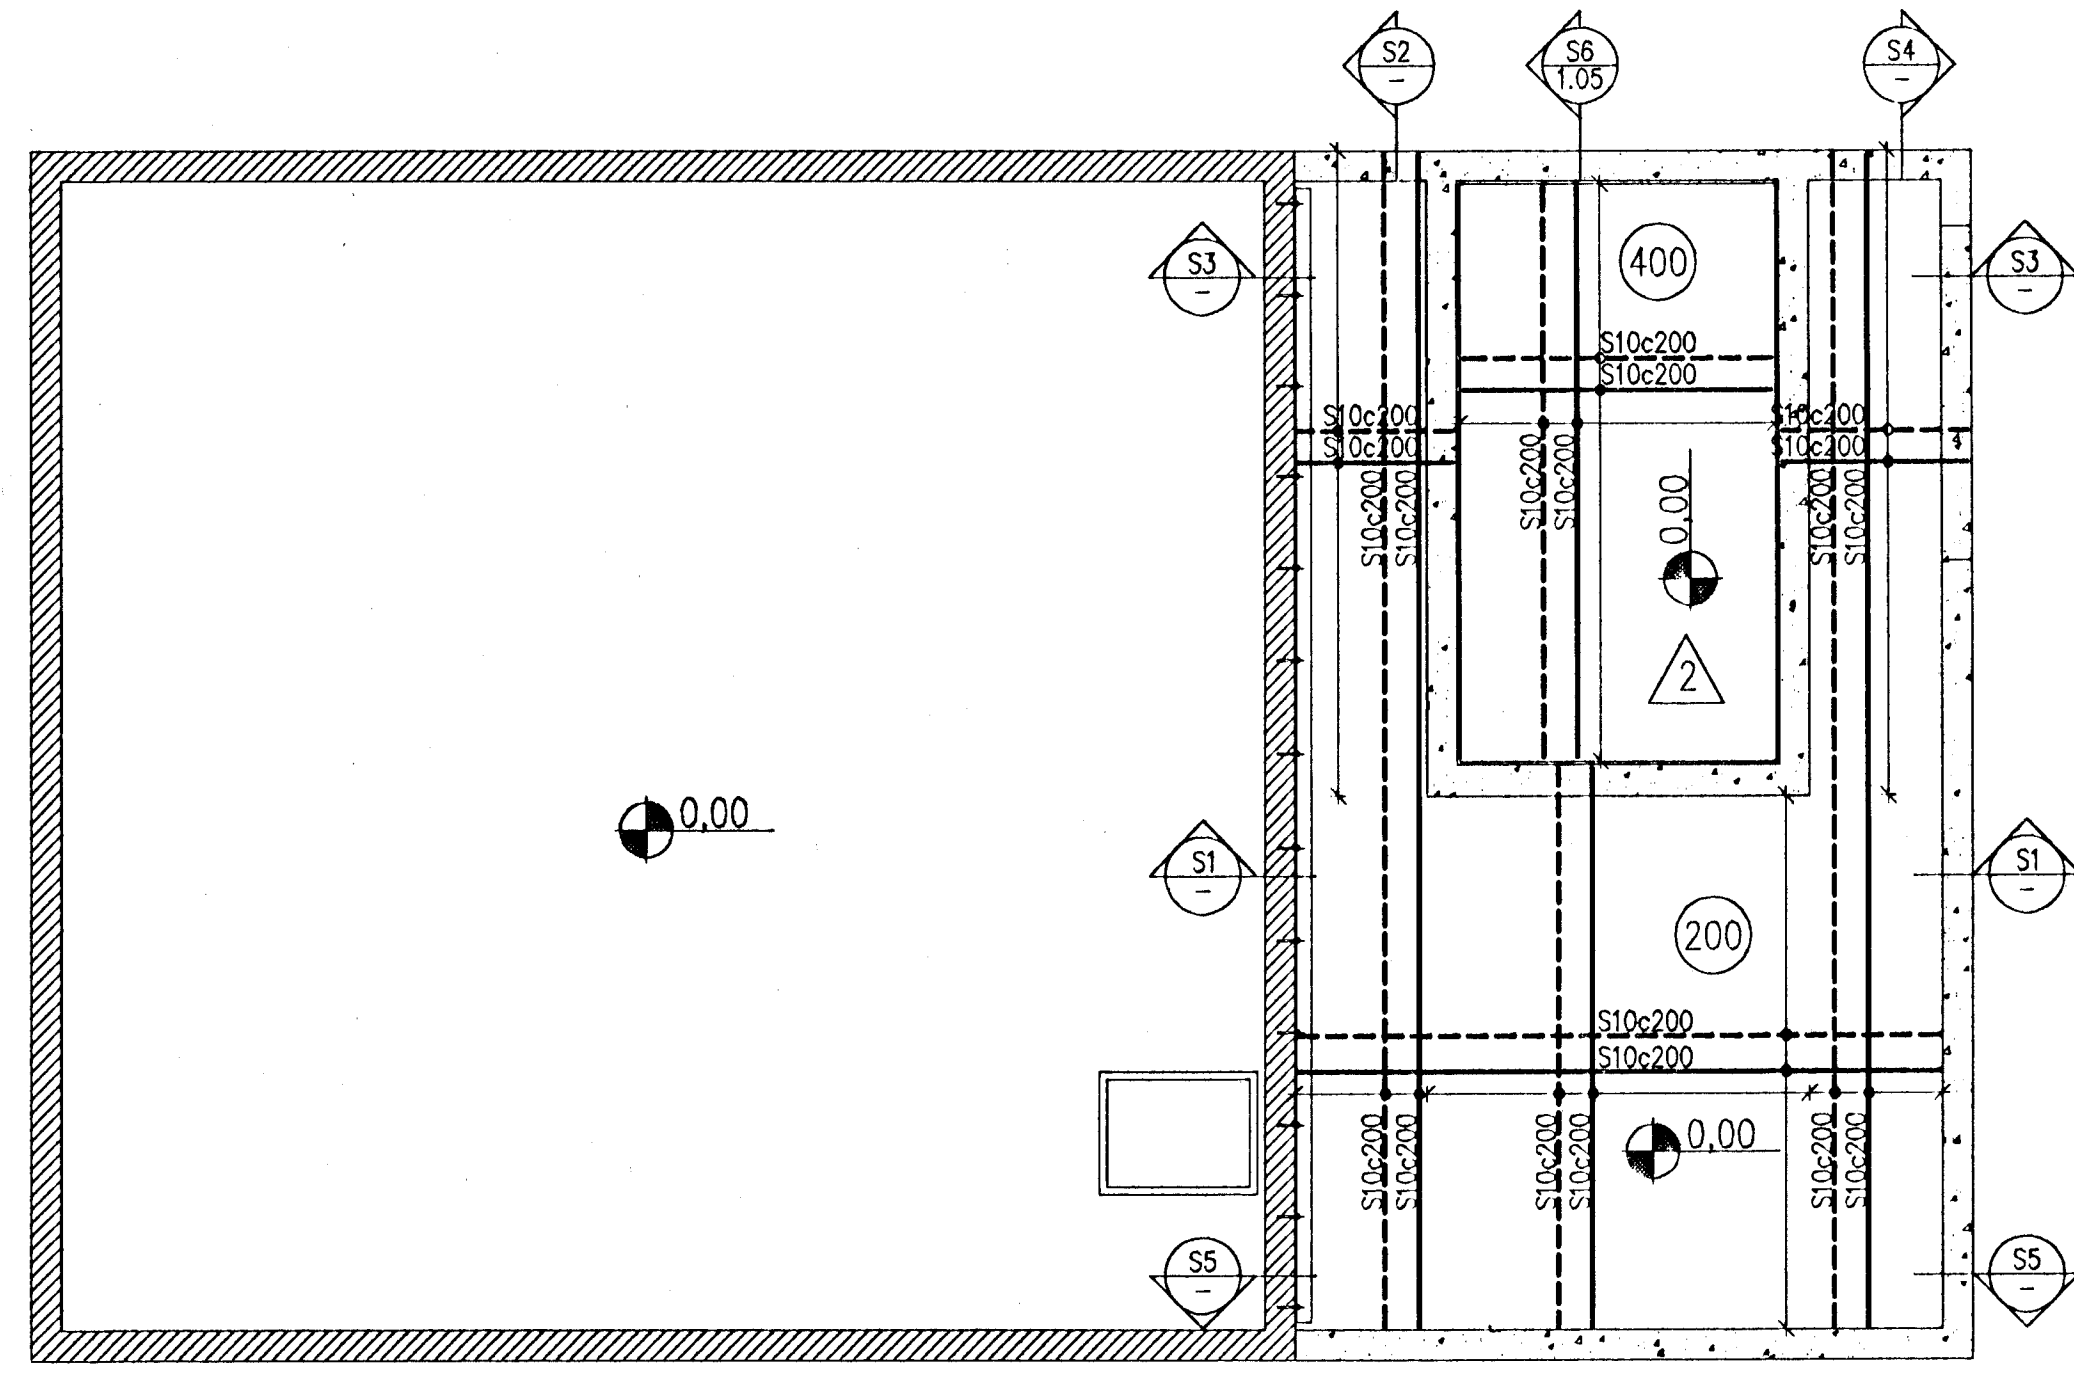

PLAN EL. 0.00

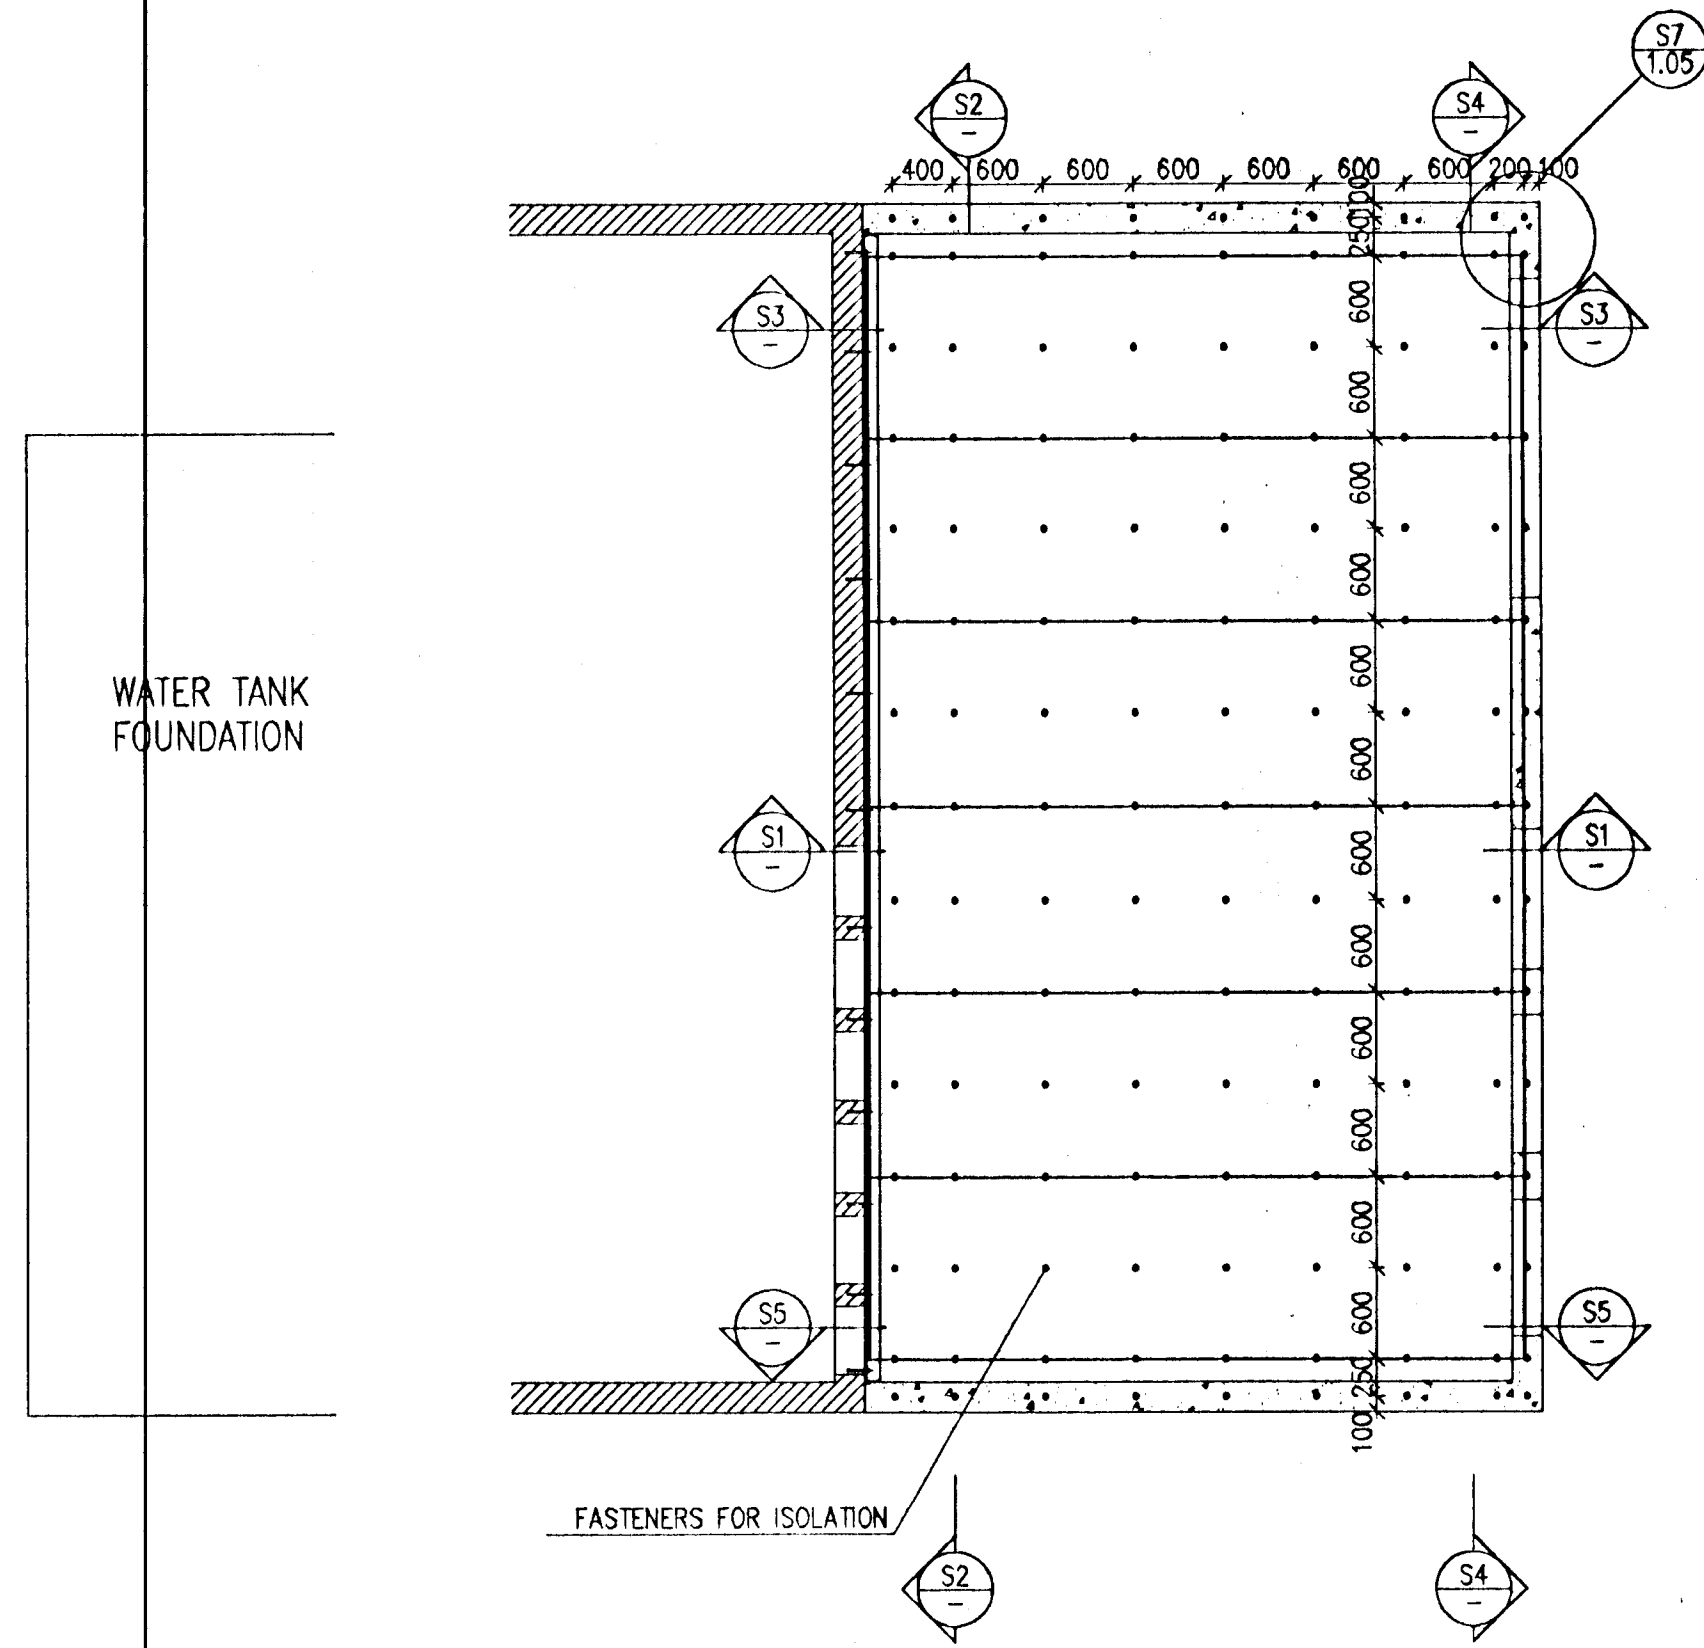

ROOF PLAN

WATER TANK FOUNDATION

 





S1

S2

S3

S4

S5

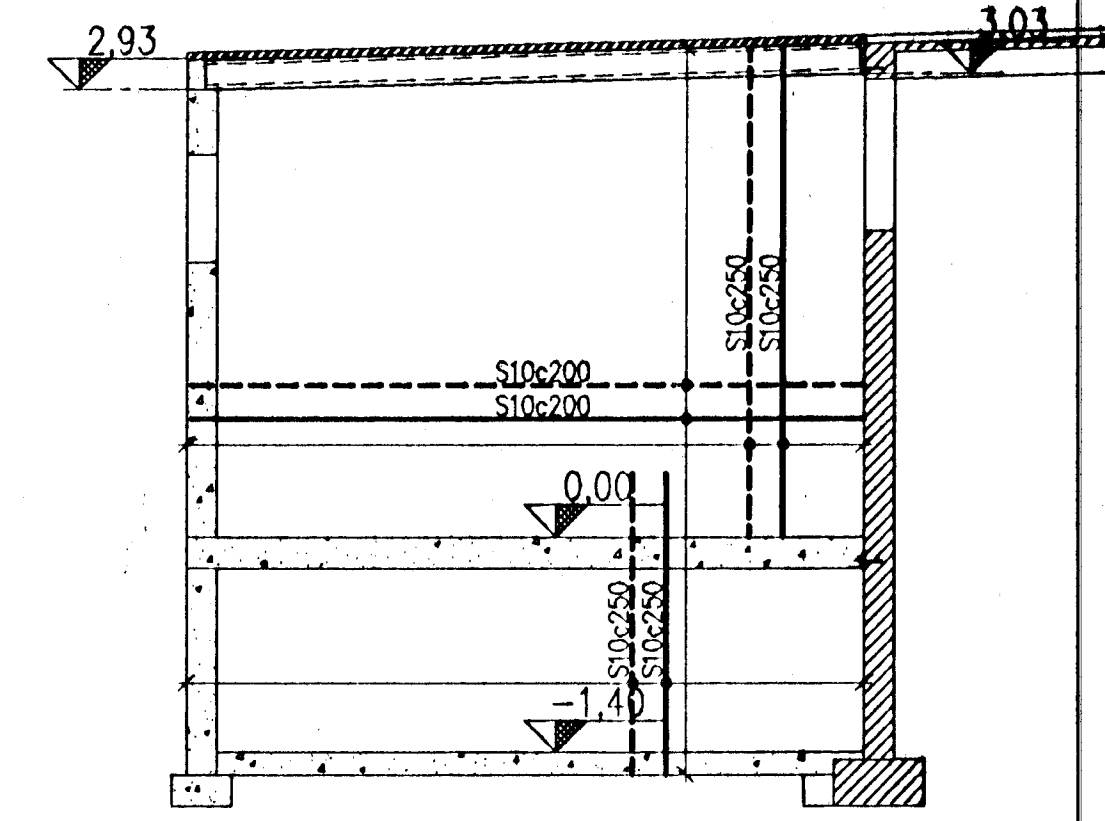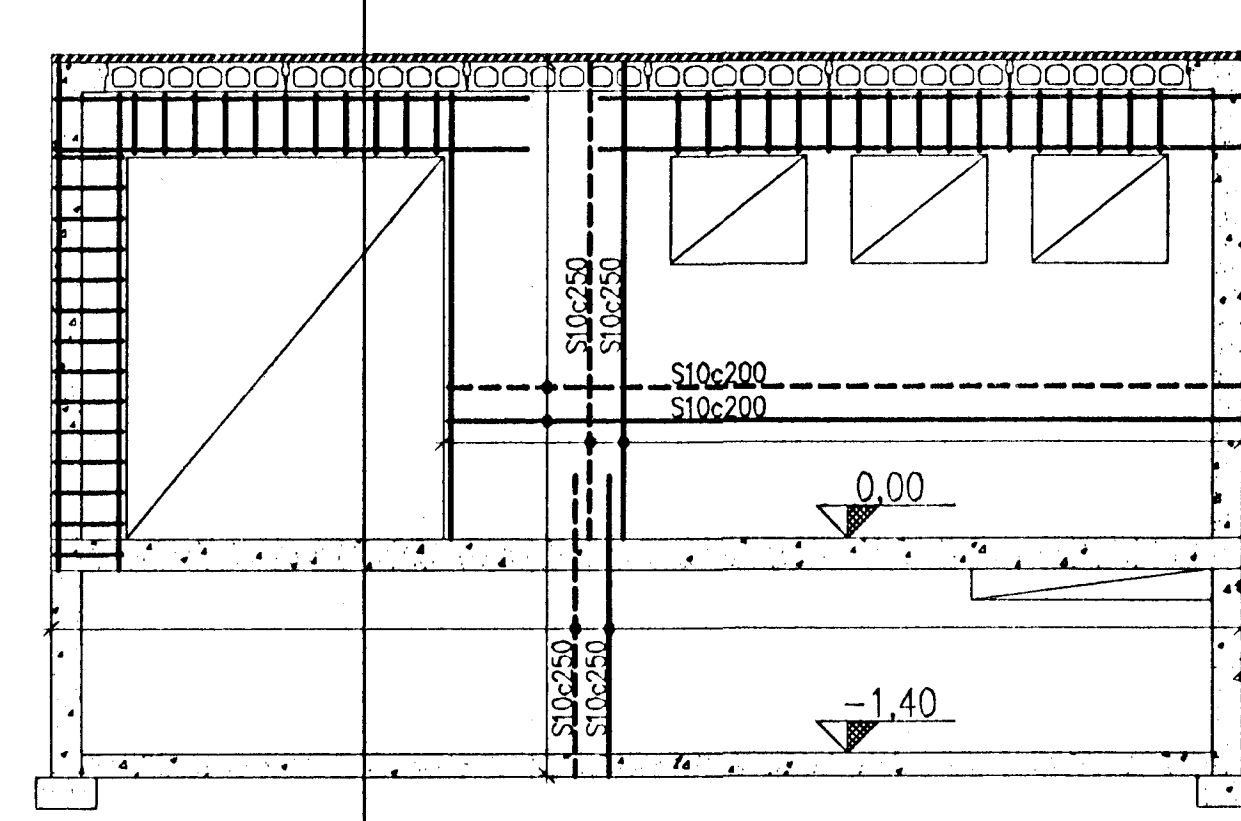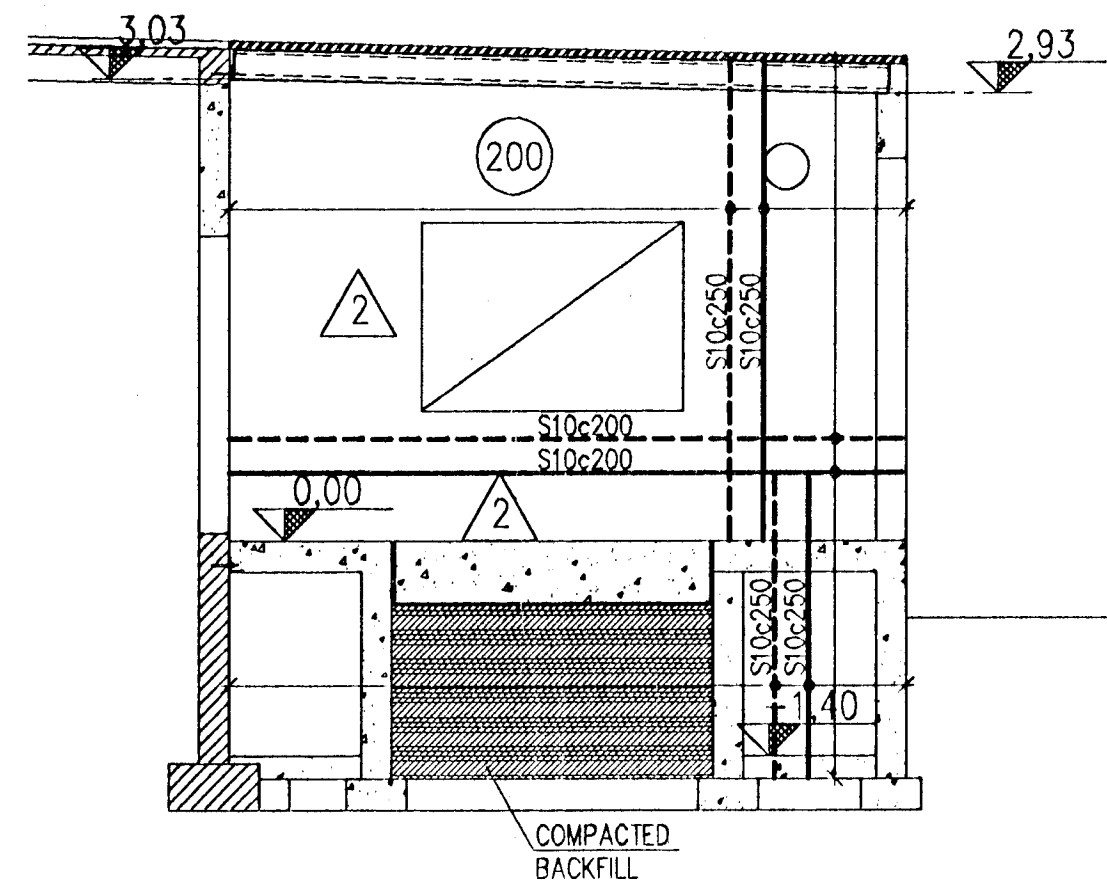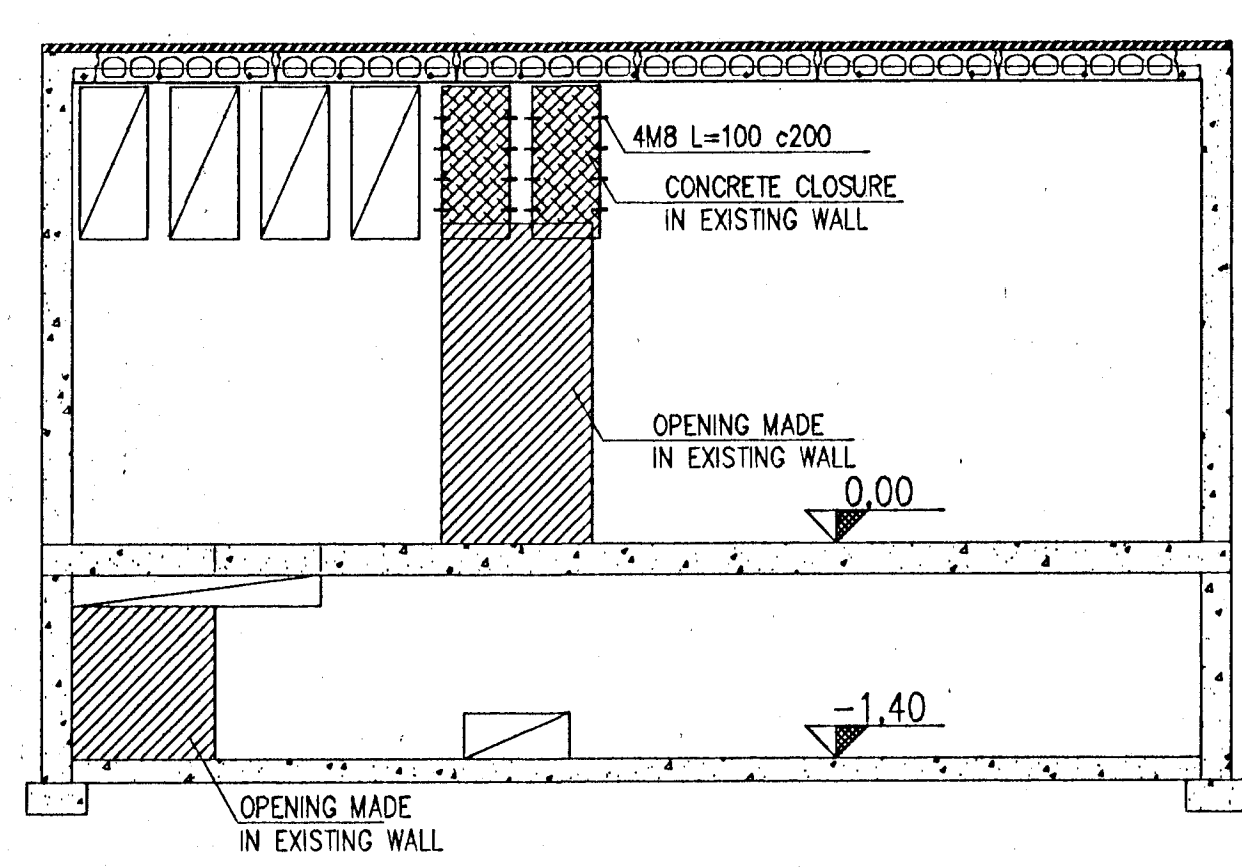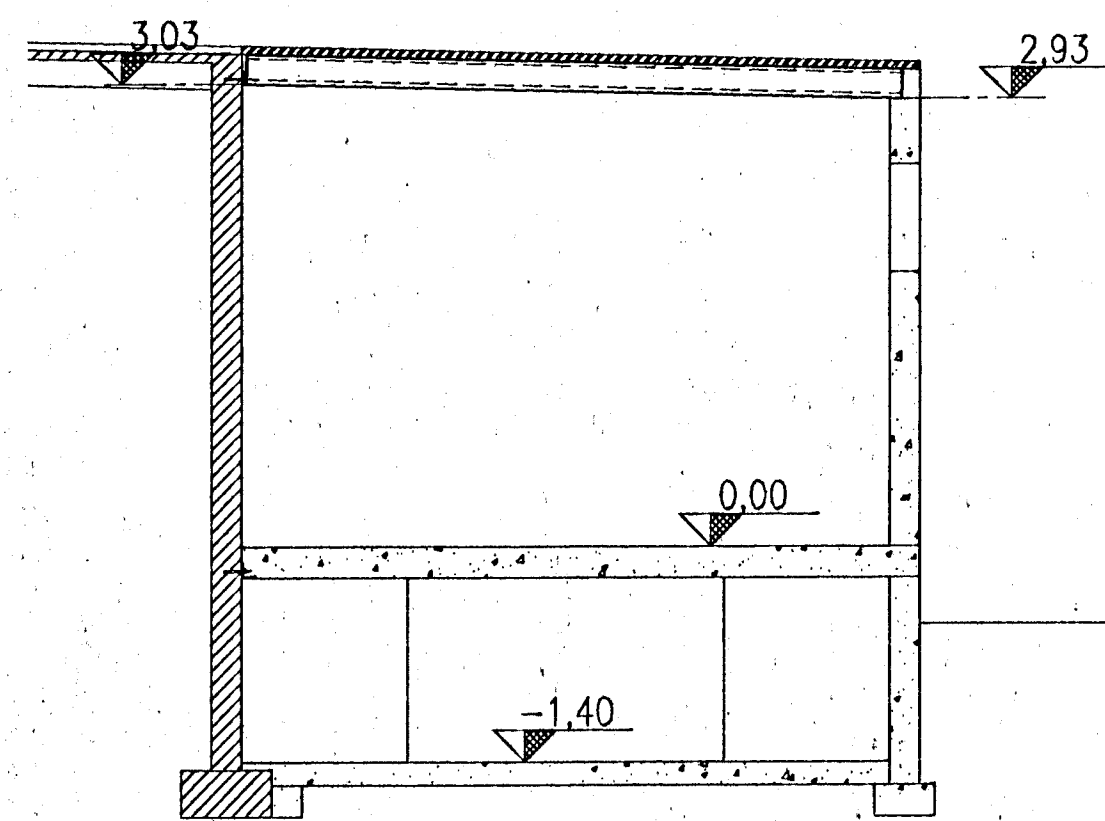

4-12-97
CP

| REV. NO. | DATE | REVISION | BY | APP. | REV. NO. | DATE | REVISION | BY | APP. | NOTES | REFERENCE DRAWING | DRAWING NUMBER |
|----------|---------|---|----|------|----------|------|----------|----|------|-------|-------------------|----------------|
| 2 | 1/4 '97 | GENERATOR FOUNDATION AND SIZE OF VENT. OPENINGS | KS | K.S. | | | | | | | | |
| 1 | 3/3 '97 | APPROVED FOR CONSTRUCTION | KS | K.S. | | | | | | | | |

| | |
|---|---|
| VST CONSULTING ENGINEERS LTD. Armula 4 108 Reykjavik Iceland Tel: +354 569 5000 Fax: +354 569 5010 | 95.120 - 36.104 |
| | WATER SUPPLY SYSTEM CONCRETE STRUCTURE SUBSTATION 66 - EXTENSION REINFORCEMENT |
| ICELANDIC ALUMINIUM COMPANY LTD. | 79000-32904 |
| ALUSUISSE ALUSA ZURICH SWITZERLAND | 192.104 |
| ICELANDIC ALUMINIUM CO. LTD | 2 |